

NOTES
 * ALL DIMENSION ARE IN FT & INCHES.
 * DIMENSION SHOULD BE READ & NOT TO BE MEASURED
 * ANY AMBIGUITY SHALL BE IMMEDIATELY REFERRED TO THE CONSULTANT
 * IT IS MUST TO INFORM AND TO HAVE PRIOR PERMISSION OF CONSULTANT BEFORE MAKING ANY CHANGES ON SITE
 * REFER THE LATEST REVISED DRAWING.
 * THIS DRAWING IS PROPERTY OF 'RECON INDUSTRIES' AND NOT TO BE COPIED OR USED WITHOUT OUR WRITTEN PERMISSION BY MR KARAN PATEL


REVISIONS		PRINT SCHEDULE				
DATE	REMARKS	DATE	CLIENT	ELECTRICAL CONTRACTOR	CIVIL CONTRACTOR	PLUMBING CONTRACTOR

PROJECT
 Gujarat Biotechnology University
 SCALE : N.T.S

CIVIL WORK DIMENSION PLAN
 DRG NO: 01
 CHCKED:
 DATE:07-11-2023
 DRG BY: B.N

RECON INDUSTRIES
 KARAN PATEL
 6, AMRUTLAL ESTATE , NR.KEWAL WEIGH BRIDGE, NAGARWEL HANUMAN ROAD , RAKHIAL , AHMEDABAD GUJARAT, E-mail:- reconindustries1@gmail.com CONTACT NO " 7043335739 , 8884940713



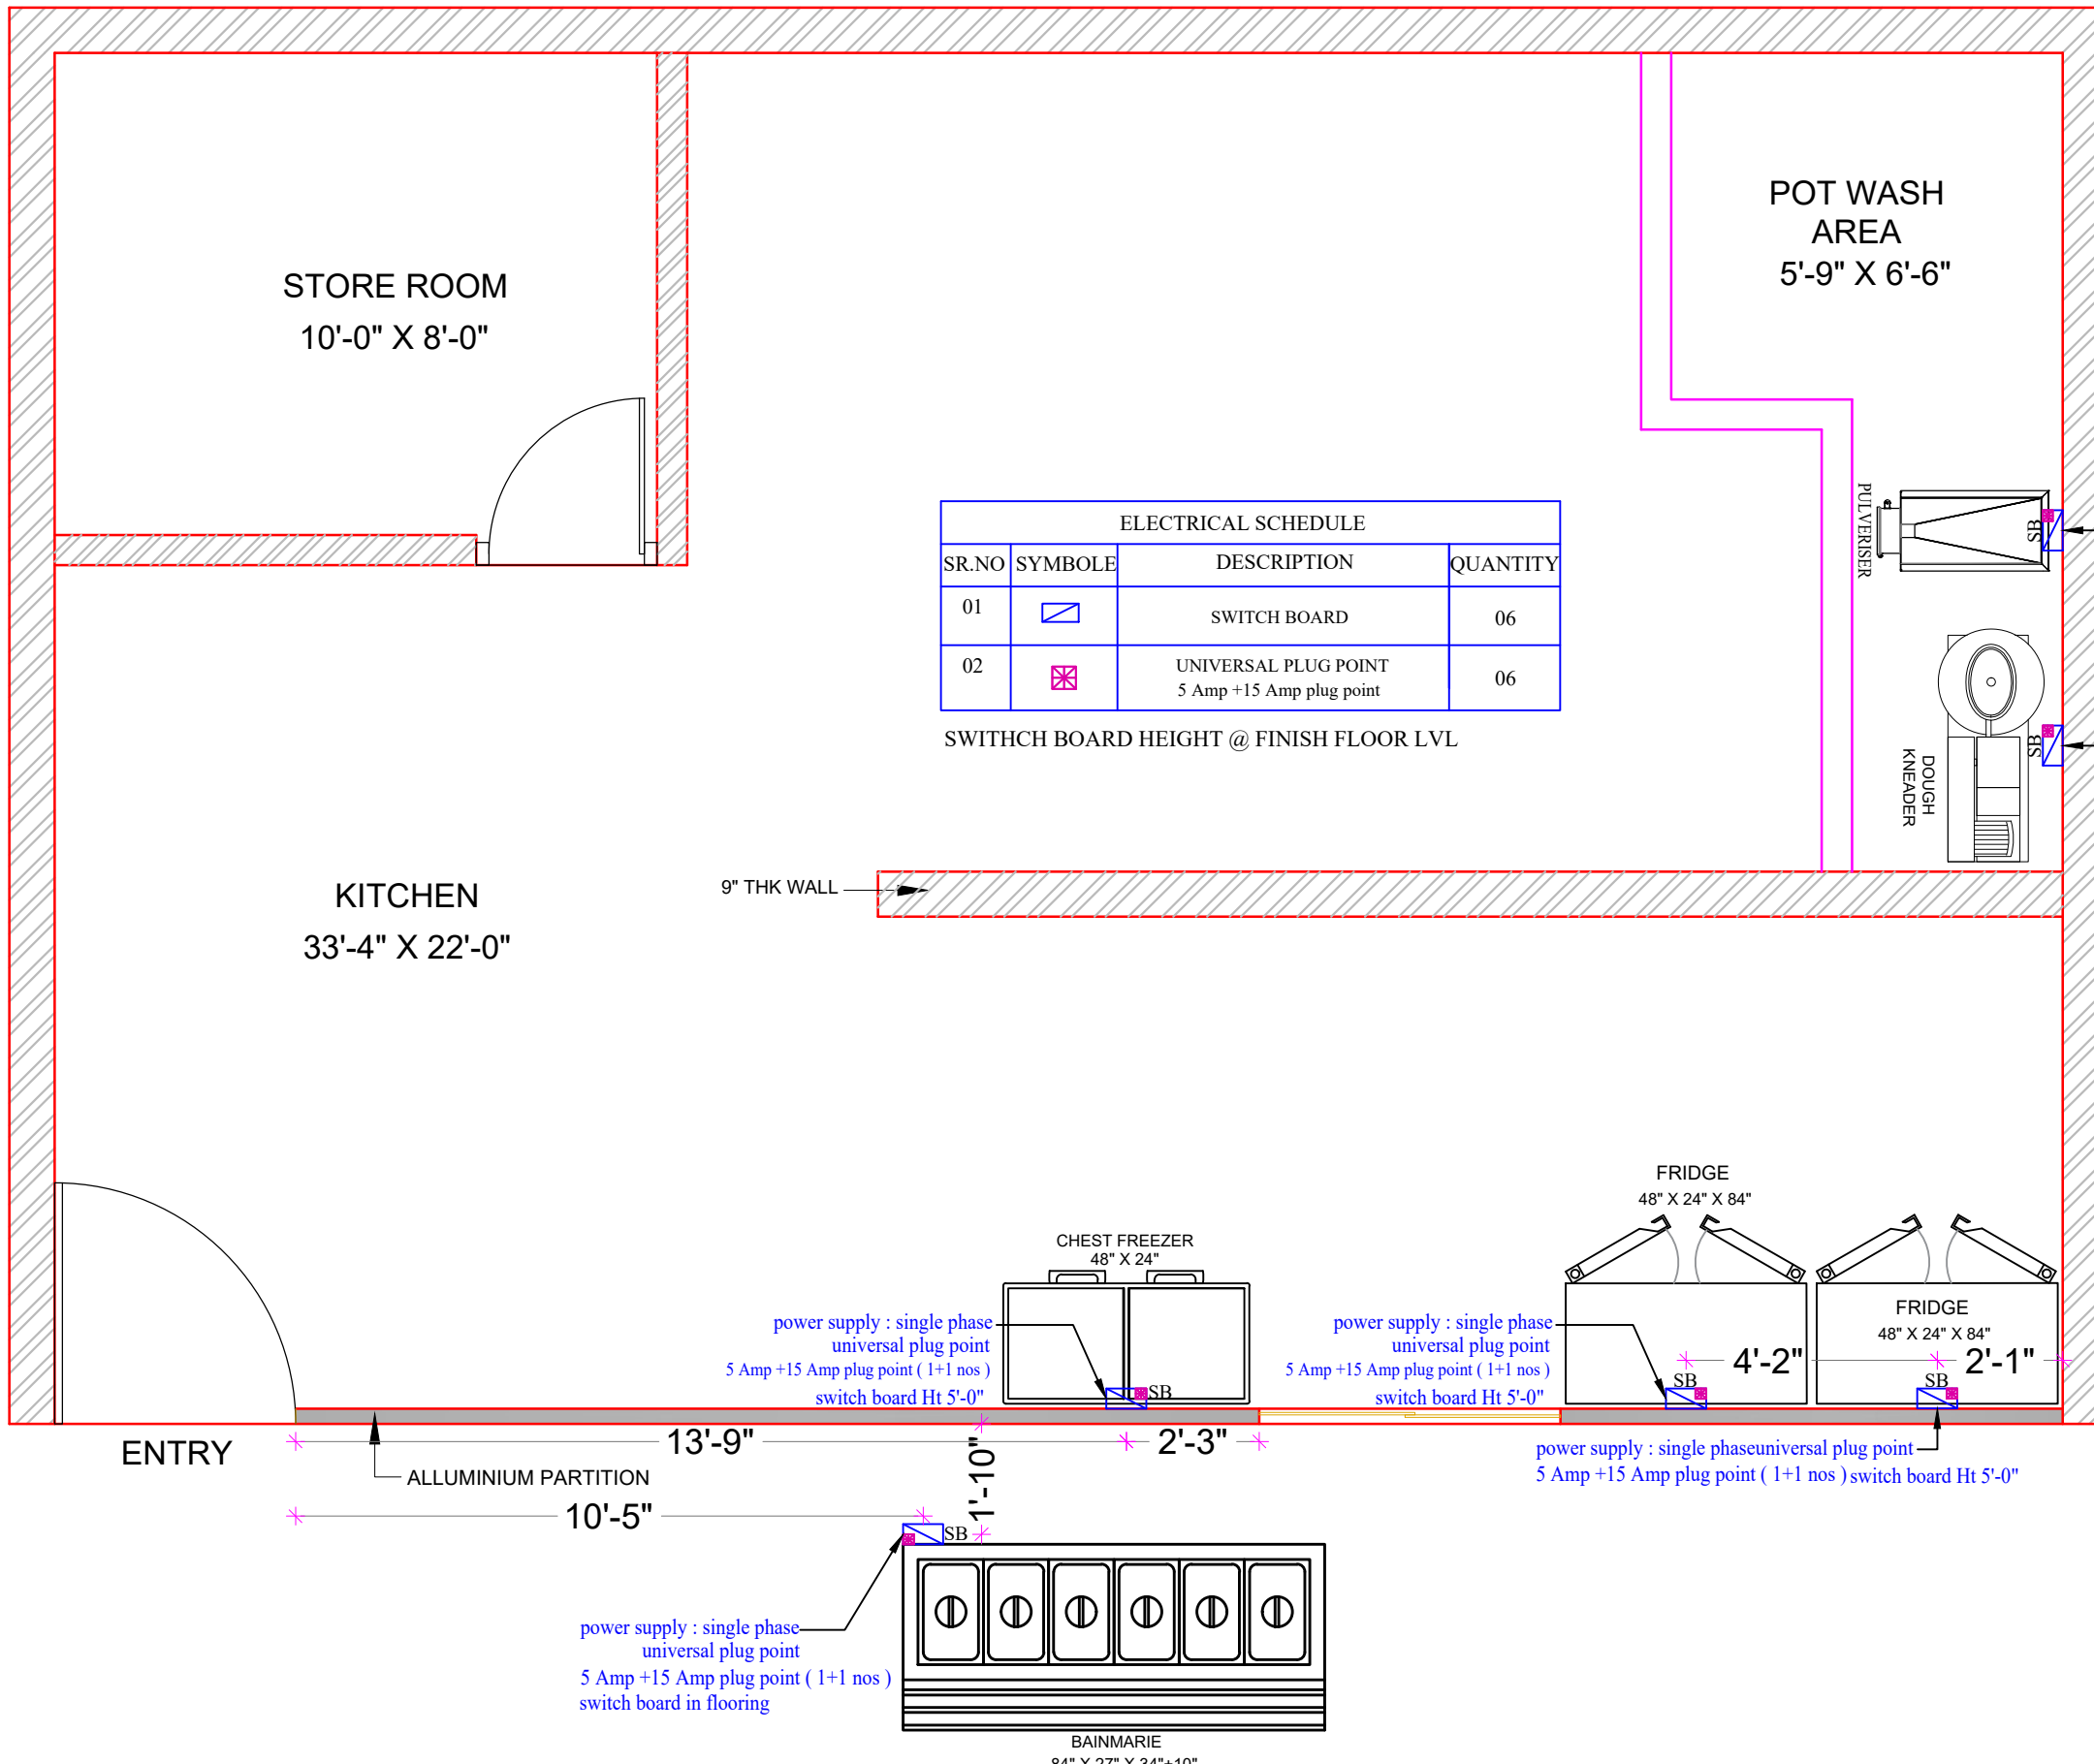

ELECTRICAL SCHEDULE			
SR.NO	SYMBOL	DESCRIPTION	QUANTITY
01		SWITCH BOARD	06
02		UNIVERSAL PLUG POINT 5 Amp +15 Amp plug point	06

SWITCH BOARD HEIGHT @ FINISH FLOOR LVL

power supply : single phase universal plug point
5 Amp +15 Amp plug point (1+1 nos)
switch board Ht 5'-0"

power supply : single phase universal plug point
5 Amp +15 Amp plug point (1+1 nos)
switch board Ht 5'-0"

9" THK WALL

power supply : single phase
universal plug point
5 Amp +15 Amp plug point (1+1 nos)
switch board Ht 5'-0"


power supply : single phase
universal plug point
5 Amp +15 Amp plug point (1+1 nos)
switch board Ht 5'-0"

power supply : single phase universal plug point
5 Amp +15 Amp plug point (1+1 nos)
switch board Ht 5'-0"

power supply : single phase
universal plug point
5 Amp +15 Amp plug point (1+1 nos)
switch board in flooring

ENTRY

ALLUMINIUM PARTITION
13'-9"
10'-5"

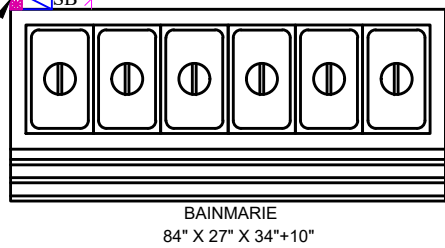

NOTES
 * ALL DIMENSION ARE IN FT & INCHES.
 * DIMENSION SHOULD BE READ & NOT TO BE MEASURED
 * ANY AMBIGUITY SHALL BE IMMEDIATELY REFERRED TO THE CONSULTANT
 * IT IS MUST TO INFORM AND TO HAVE PRIOR PERMISSION OF CONSULTANT BEFORE MAKING ANY CHANGES ON SITE
 * REFER THE LATEST REVISED DRAWING.
 * THIS DRAWING IS PROPERTY OF ' RECON INDUSTRIES ' AND NOT TO BE COPIED OR USED WITHOUT OUR WRITTEN PERMISSION BY MR KARAN PATEL


REVISIONS		PRINT SCHEDULE			
DATE	REMARKS	DATE	CLIENT	REMARKS	
			ELECTRICAL CONTRACTOR		
			CIVIL CONTRACTOR		
			PLUMBING CONTRACTOR		



PROJECT
Gujarat Biotechnology University
 SCALE : N.T.S

ELECTRICAL PLAN
 DRG NO: 01
 DATE: 17-09-2023
 CHCKED:
 DRG BY: B.N

RECON INDUSTRIES
 KARAN PATEL
 6, AMRUTLAL ESTATE , NR.KEWAL WEIGH BRIDGE,
 NAGARWEL HANUMAN ROAD , RAKHIAL , AHMEDABAD
 GUJARAT , E-mail:- reconindustries1@gmail.com
 CONTACT NO " 7043335739 , 8884940713

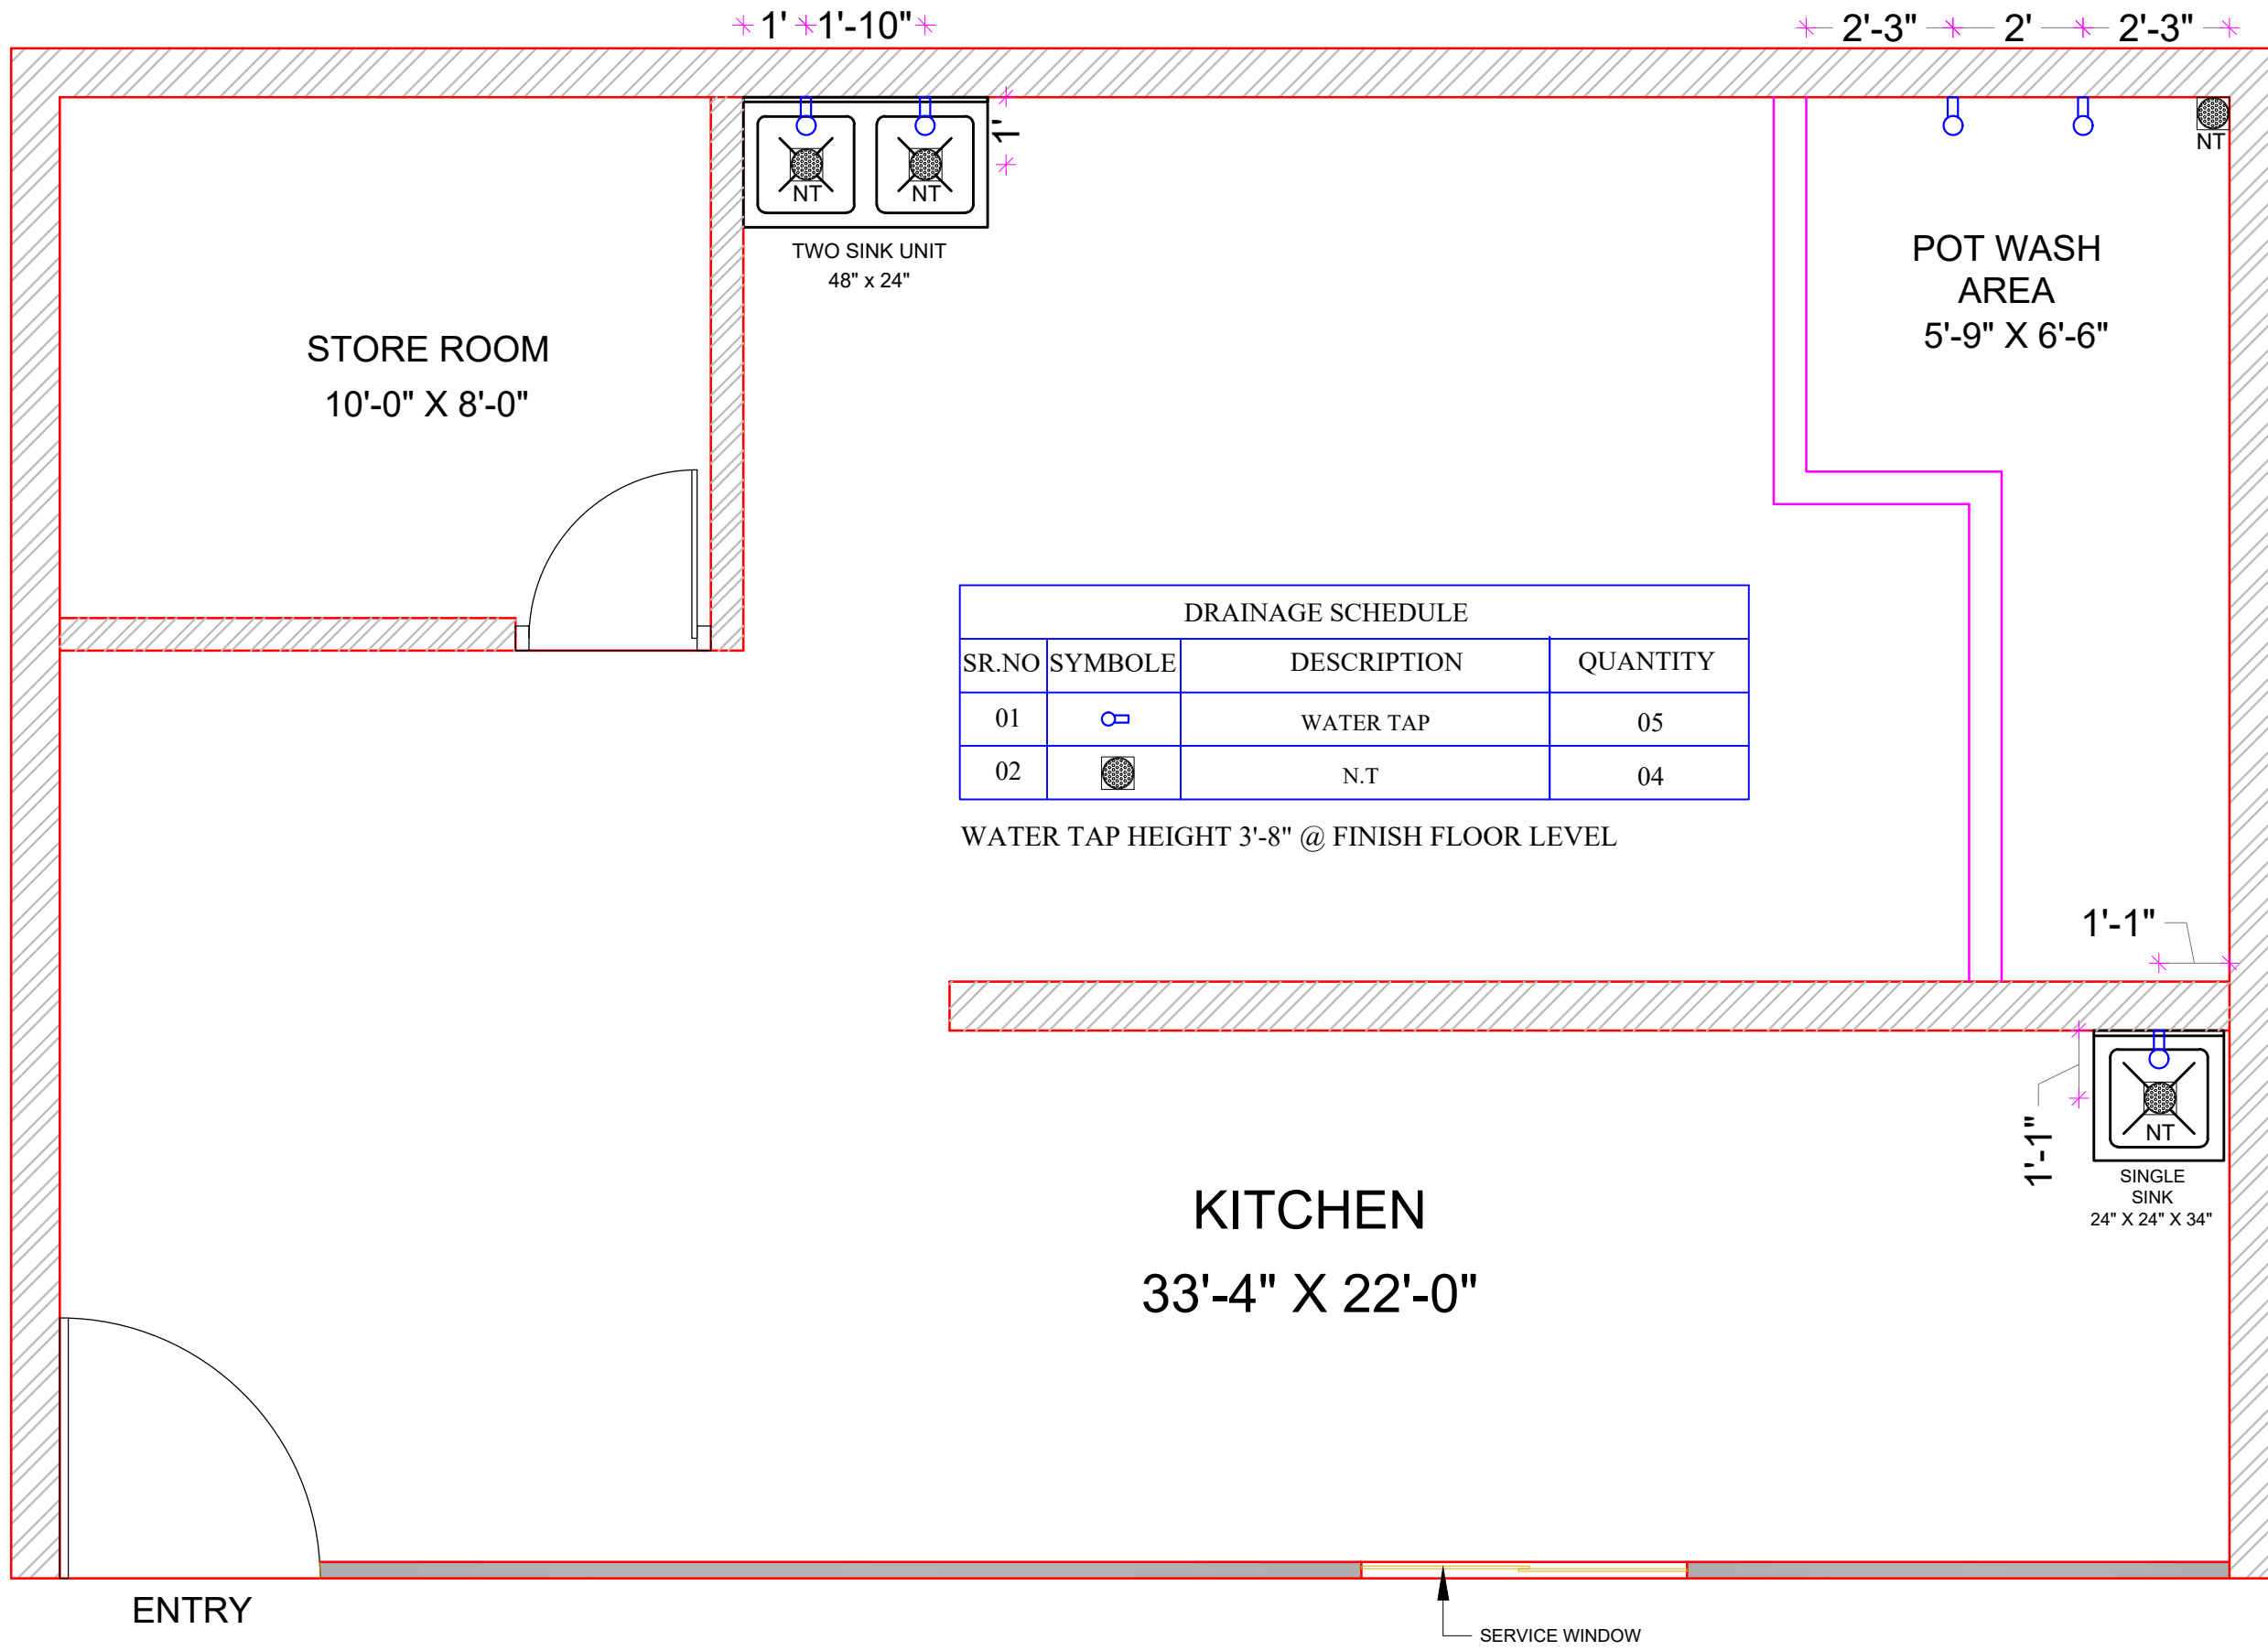



DRAINAGE SCHEDULE			
SR.NO	SYMBOLE	DESCRIPTION	QUANTITY
01		WATER TAP	05
02		N.T	04

WATER TAP HEIGHT 3'-8" @ FINISH FLOOR LEVEL

NOTES
 * ALL DIMENSION ARE IN FT & INCHES.
 * DIMENSION SHOULD BE READ & NOT TO BE MEASURED
 * ANY AMBIGUITY SHALL BE IMMEDIATELY REFERRED TO THE CONSULTANT
 * IT IS MUST TO INFORM AND TO HAVE PRIOR PERMISSION OF CONSULTANT BEFORE MAKING ANY CHANGES ON SITE
 * REFER THE LATEST REVISED DRAWING.
 * THIS DRAWING IS PROPERTY OF ' RECON INDUSTRIES ' AND NOT TO BE COPIED OR USED WITHOUT OUR WRITTEN PERMISSION BY MR.KARAN PATEL


REVISIONS		PRINT SCHEDULE				
DATE	REMARKS	DATE	CLIENT	ELECTRICAL CONTRACTOR	CIVIL CONTRACTOR	PLUMBING CONTRACTOR

PROJECT
Gujarat Biotechnology University
 SCALE : N.T.S

PLUMBING LAYOUT
 DRG NO: 01 DATE:17-09-2023
 CHCKED: DRG BY: B.N

RECON INDUSTRIES
 KARAN PATEL
 6, AMRUTLAL ESTATE , NR.KEWAL WEIGH BRIDGE,
 NAGARWEL HANUMAN ROAD , RAKHIAL , AHMEDABAD
 GUJARAT, E-mail:- reconindustries1@gmail.com
 CONTACT NO " 7043335739 , 8884940713



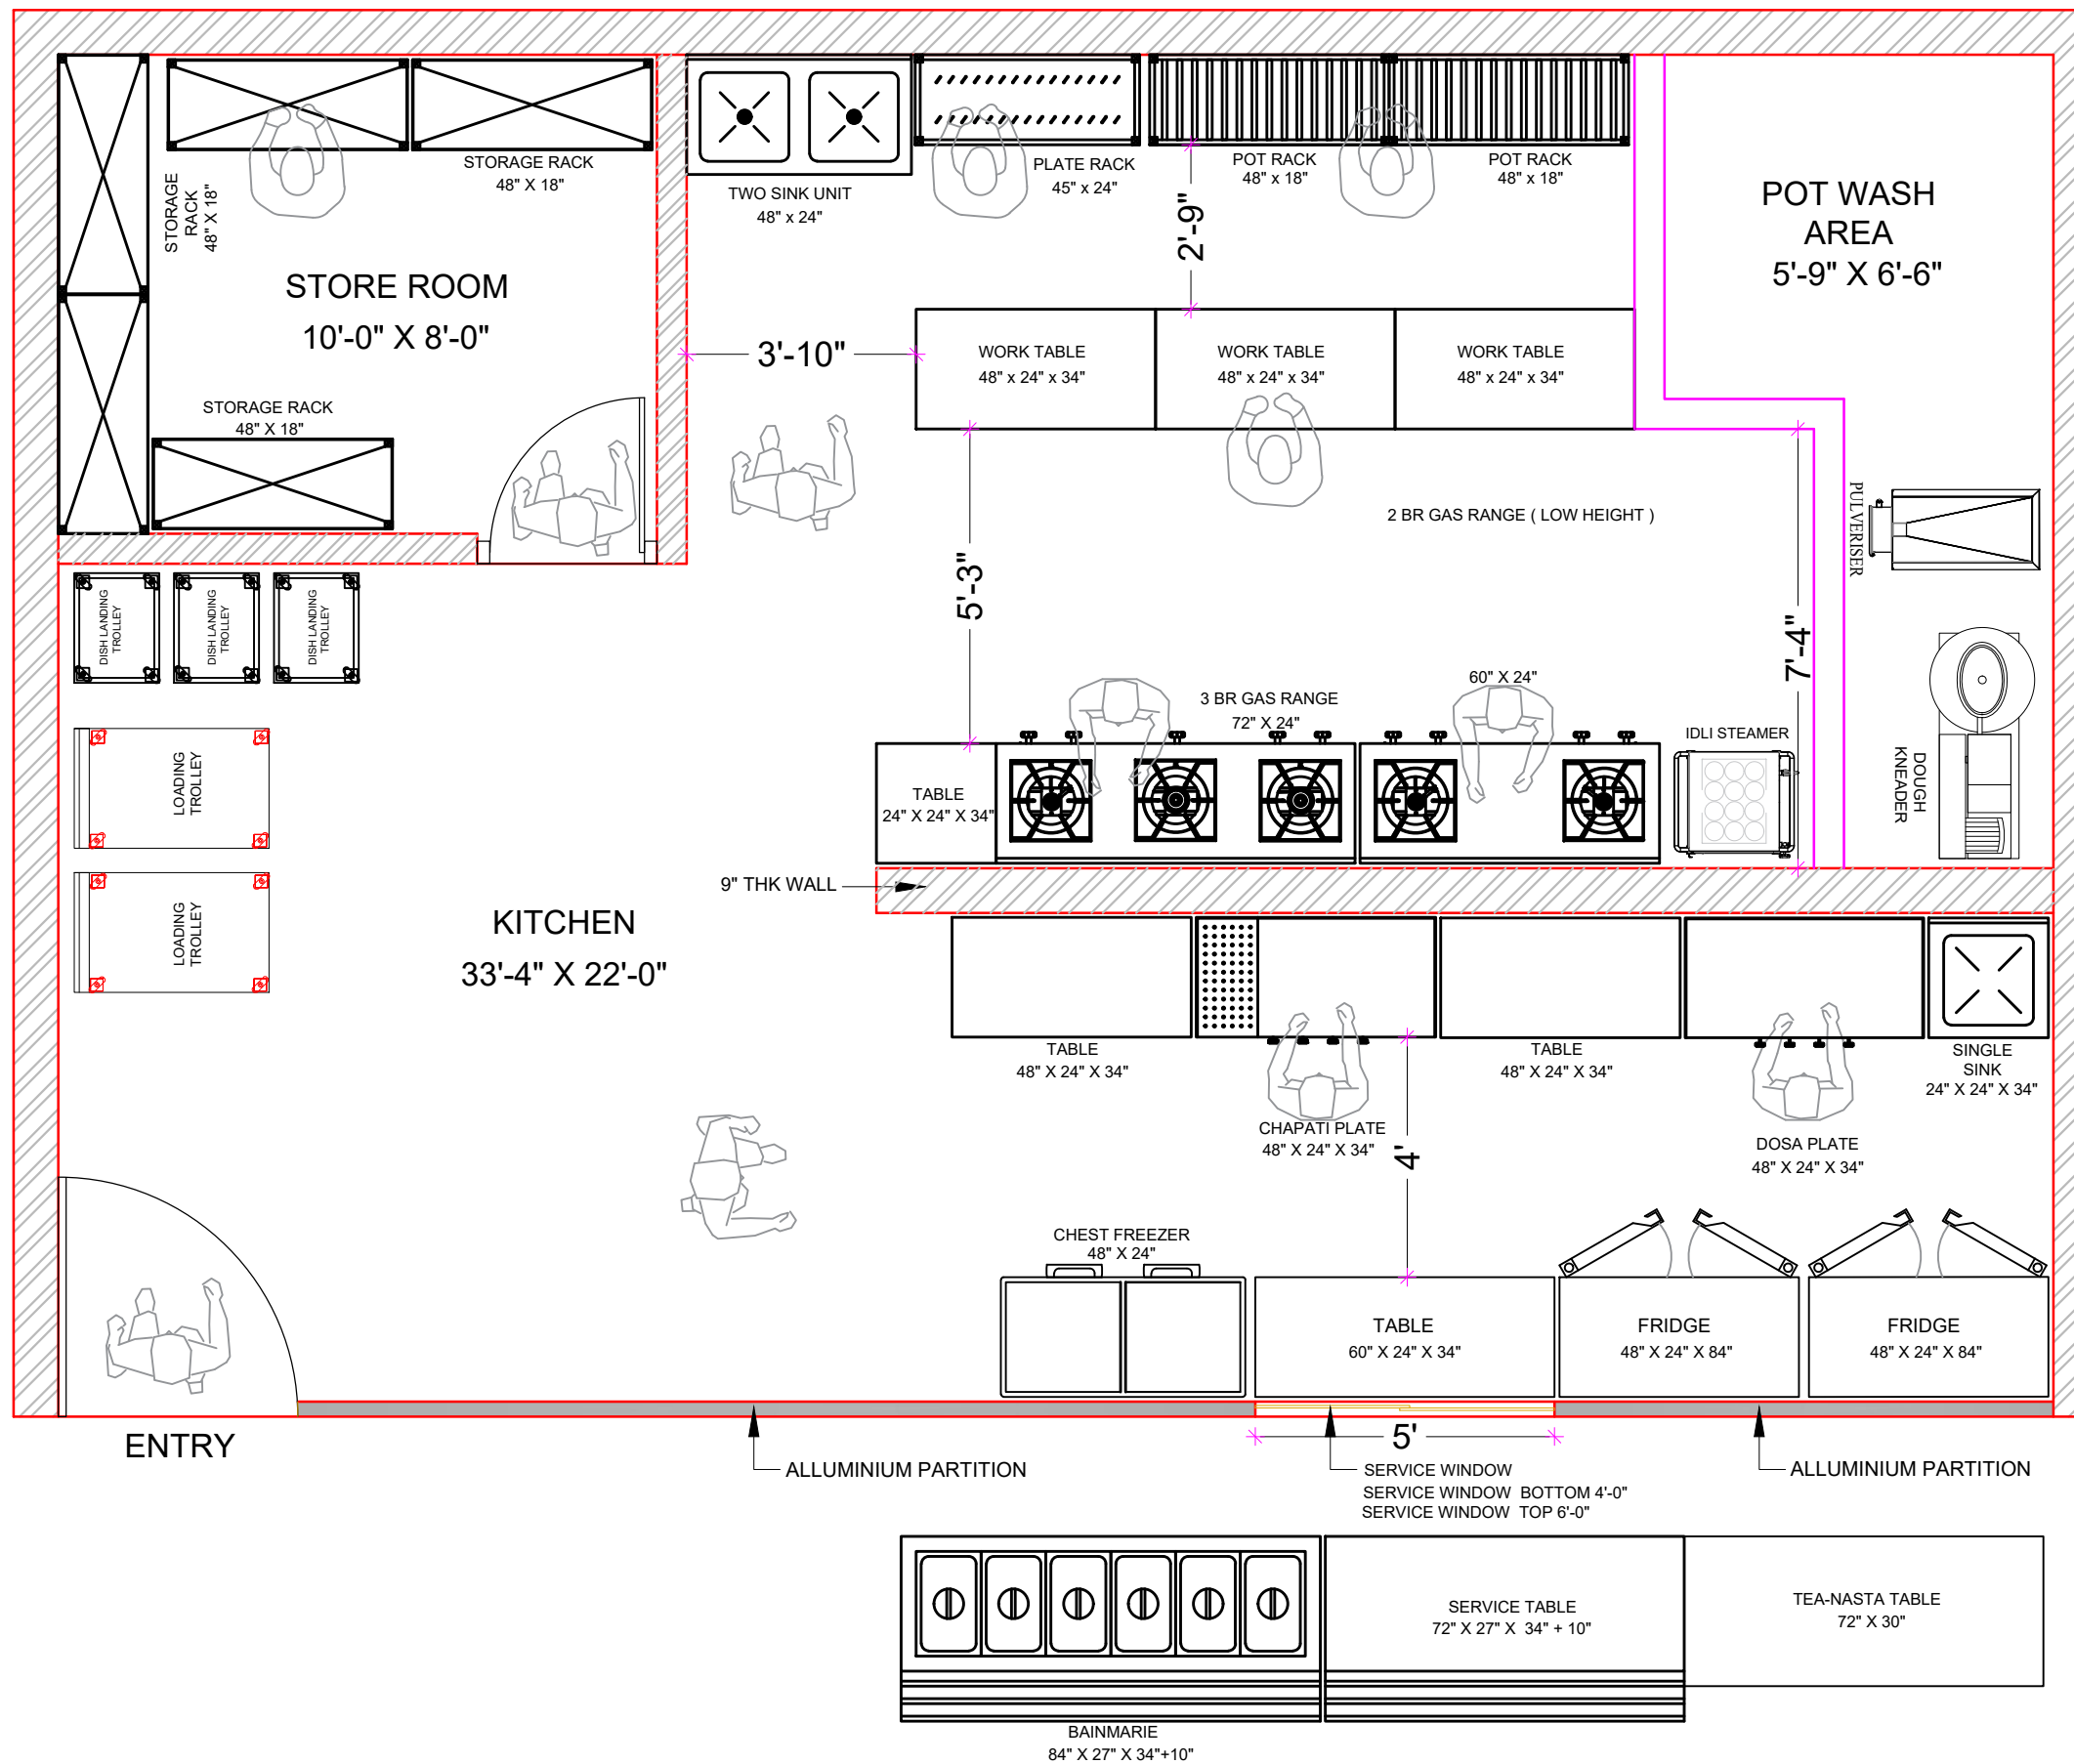

NOTES
 * ALL DIMENSION ARE IN FT & INCHES.
 * DIMENSION SHOULD BE READ & NOT TO BE MEASURED
 * ANY AMBIGUITY SHALL BE IMMEDIATELY REFERRED TO THE CONSULTANT
 * IT IS MUST TO INFORM AND TO HAVE PRIOR PERMISSION OF CONSULTANT BEFORE MAKING ANY CHANGES ON SITE
 * REFER THE LATEST REVISED DRAWING.
 * THIS DRAWING IS PROPERTY OF ' RECON INDUSTRIES ' AND NOT TO BE COPIED OR USED WITHOUT OUR WRITTEN PERMISSION BY MR KARAN PATEL

REVISIONS		PRINT SCHEDULE			
DATE	REMARKS	DATE	CLIENT	REMARKS	
			ELECTRICAL CONTRACTOR		
			CIVIL CONTRACTOR		
			PLUMBING CONTRACTOR		

PROJECT
 Gujarat Biotechnology University
 SCALE : N.T.S

R-1 KITCHEN LAYOUT
 DRG NO: 01
 CHCKED:
 DATE:17-09-2023
 DRG BY: B.N

RECON INDUSTRIES
 KARAN PATEL
 6, AMRUTLAL ESTATE , NR.KEWAL WEIGH BRIDGE, NAGARWEL HANUMAN ROAD , RAKHIAL , AHMEDABAD GUJARAT, E-mail:- reconindustries1@gmail.com CONTACT NO " 7043335739 , 8884940713

