
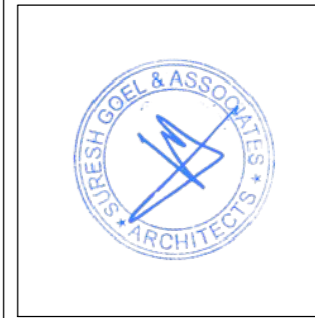


HOSTEL BLOCK

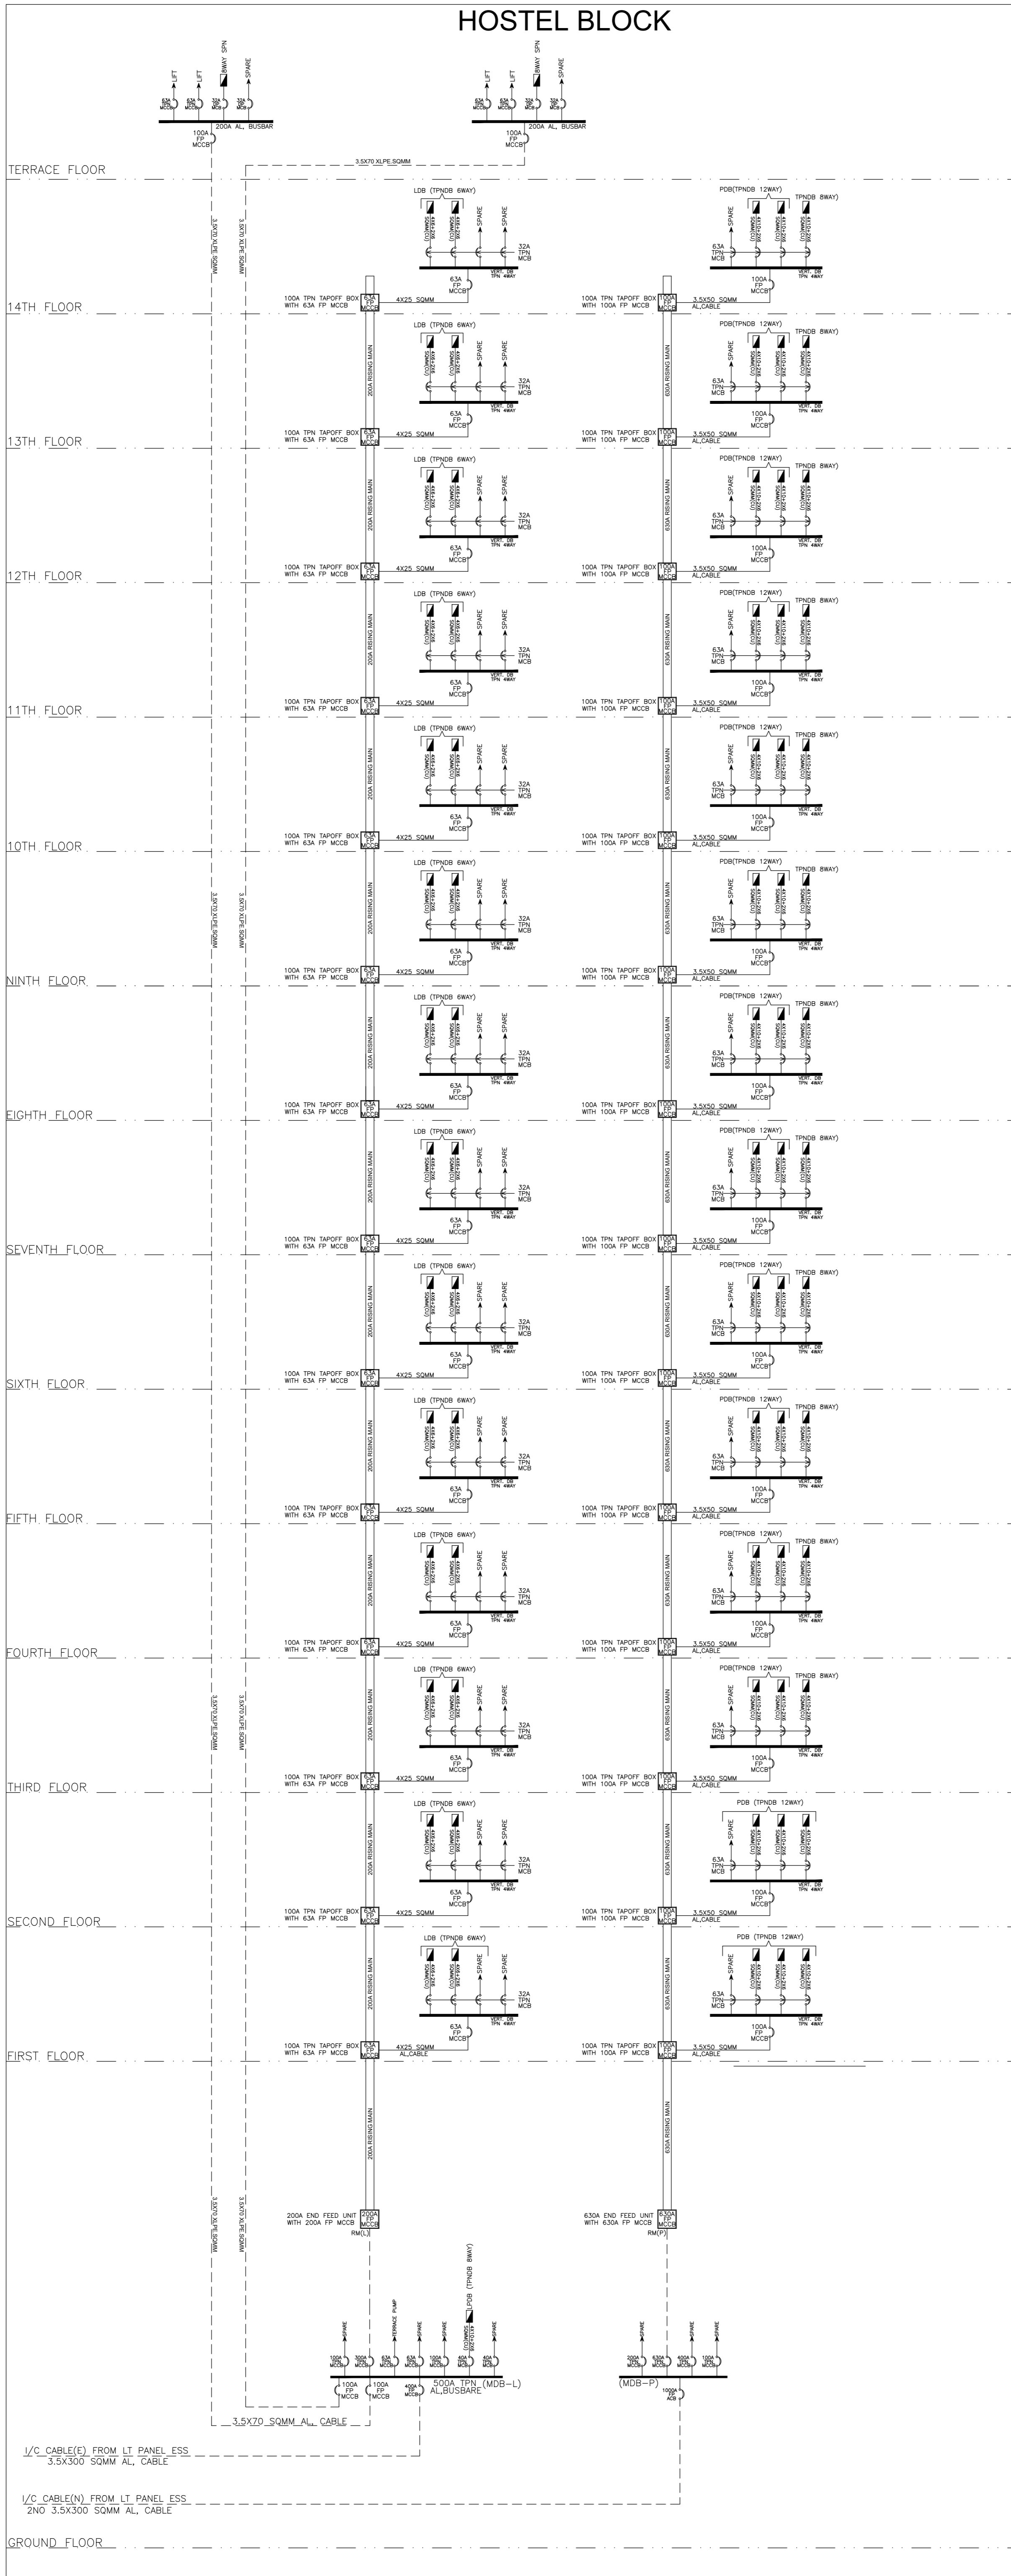

DATE	REV.	REV. BY	DESCRIPTION	DATE	NO.	ISSUED TO
ARCHITECT SURESH GOEL AND ASSOCIATES ARCHITECTS . ENGINEERS . PLANNERS						
DWG ISSUED ON - 23/08/23			AT - NEW DELHI	PROJECT CODE		
SIG			SIG	202210		
Originated by	Name : S.K	Checked by	Name : R.SINGH	BUILDING CODE		
Engineered by	ENGINEER	Validated by	ENGINEER	H1		

PROJECT:
GUJARAT BIOTECHNOLOGY UNIVERSITY

C-85, SHIVALIK NEW DELHI-110017 TEL:(011)26678254,41034450 MAIL:mail@sgadesignlab.com	SANDEEP GOEL
	CHIEF ARCHITECT

N W E S	BUILDING TYPE: HOSTEL BLOCK
	DRAWING TITLE: IEI SINGLE LINE DIAGRAM
DRAWING NUMBER: 202210-GBU-S4-EL-SLD-001	REVISION
SCALE: 1 : 200	SHEET SIZE: A1

HOSTEL BLOCK