



## GUJARAT BIOTECHNOLOGY UNIVERSITY

Nr. GIFT City, GIFT City Road,

Shahpur Village, Gandhinagar- 382355

Email: [registrar@gbu.edu.in](mailto:registrar@gbu.edu.in) / [tender@gbu.edu.in](mailto:tender@gbu.edu.in)

Website: [www.gbu.edu.in/](http://www.gbu.edu.in/)



## Corrigendum-I

**Construction of Animal House and Greenhouse Facilities at Gujarat Biotechnology University**

**Tender ID: 83001, Date: 06/07/2024**

## Corrigendum I

<b>S. No</b>	<b>Clause</b>	<b>Original Clause</b>	<b>Modified Clause / New Clause</b>
1.	2.1.5	The Bid shall be furnished as per formats provided in Appendix-I of this DTP. The Bid shall include the following:  APPENDIX – III : Floor Plan / Layout	Find additional drawings in Refer Annexure I

## **Annexure I**





**LEGEND :-**


SYMB	DESCRIPTION
	2 WAY SWITCH BOARD
	SWITCH BOARD
	CEILING FAN
	EXHAUST FAN
	6 W SURFACE / RECESSED LED LIGHT
	12W SURFACE MOUNTED LED LIGHT WITH COVER
	15W RECESSED LED DIL
	15W LED MIRROR LIGHT
	20W LED BATTEN LIGHT (WALL MOUNTED)
	36/40W LED LINEAR LIGHT FITTING
	9W CFL BULKHEAD LIGHT
	100A SWITCH
	38W LED CLEAN ROOM LIGHT FITTING
	38W LED LIGHT FITTING
	INDICATING LIGHT FITTING
	TELEPHONE OUTLET
	COMPUTER POINT
	8A SWITCH SOCKET OUTLET
	2X8A LIGHT PLUG
	16A SOCKET OUTLET
	30A THREE PHASE SOCKET OUTLET
	MAIN DISTRIBUTION BOARD UPS
	FDB-U DISTRIBUTION BOARD
	LIGHT & POWER DISTRIBUTION BOARD
	UPS DISTRIBUTION BOARD
	AHU PANEL
	HEAT DETECTOR
	16A UPS POINT
	FAULT ISOLATOR
	CONTROL MODULE
	FIRE FIGHTER PHONE JACK WITH CONTROL MODULE
	SMOKE DETECTOR AT CEILING / FALSE CEILING
	SMOKE DETECTOR ABOVE / FALSE CEILING
	MANUAL CALL POINT
	HOOTER WITH CONTROL MODULE
	RESPONSE INDICATOR
	MAIN FIRE ALARM PANEL
	FIRE ALARM JUNCTION BOX
	CEILING SPEAKER
	MAIN PA PANEL
	DATA RACK
	DOUBLE CIRCLE SENCER
	DOME CAMERA
	PTZ CAMERA
	BULLET CAMERA
	EXIT LIGHT
	FIRE FIGHTER TELEPHONE

ISSUED FOR: TENDER PURPOSE SHEET NO. 1

Drawing Title: ANIMAL FACILITY BLOCK  
 BASEMENT FLOOR ELECTRICAL LAYOUT  
 Project Title: GUJARAT BIOTECHNOLOGY UNIVERSITY, GIFT CITY, GANDHINAGAR, GUJARAT.

Drawing Number: 202210-GBU-AH-54-EL-001  
 Revision: North  
 Scale: 1:100  
 Date: 05/04/24

**NOTE:**  
 1. Do not scale the drawing.  
 2. Only written dimensions and UTM coordinate reference provided to be followed.  
 3. All dimensions are in mm /cm /m

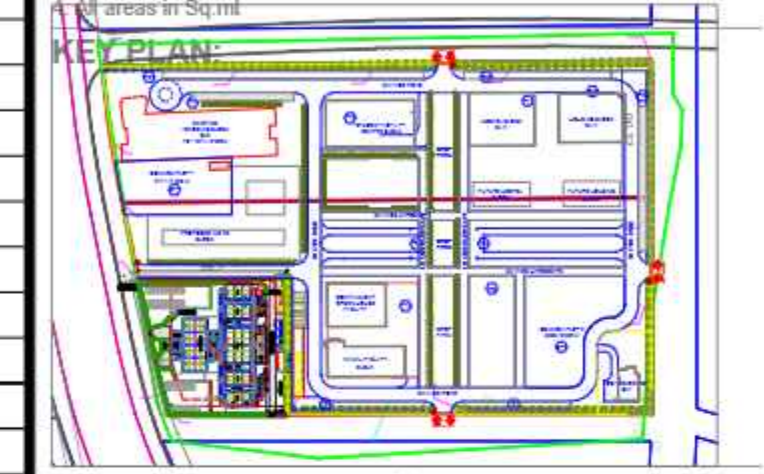

**LEGEND:**

	FIRE FIGHTER PHONE JACK WITH CONTROL MODULE
	SMOKE DETECTOR AT CEILING / FALSE CEILING
	SMOKE DETECTOR ABOVE / FALSE CEILING
	MANUAL CALL POINT
	HOOTER WITH CONTROL MODULE
	RESPONSE INDICATOR
	MAIN FIRE ALARM PANEL
	FIRE ALARM JUNCTION BOX
	CEILING SPEAKER
	MAIN PA PANEL
	DATA RACK
	DOUBLE CIRCLE SENCER
	DOME CAMERA
	PTZ CAMERA
	BULLET CAMERA
	EXIT LIGHT
	FIRE FIGHTER TELEPHONE

DEVELOPER: GUJARAT BIOTECHNOLOGY UNIVERSITY



ARCHITECT: SURESH GOEL AND ASSOCIATES  
 ARCHITECTS - ENGINEERS - PLANNERS  
 C-85, SHIVALIK NEW DELHI-110017  
 TEL:(011)26676254,41034450  
 MAIL:mail@sgadesignlab.com  
 GIFT Urban Development Authority:




Drawing Title: ANIMAL FACILITY BLOCK  
 Project Title: GUJARAT BIOTECHNOLOGY UNIVERSITY, GIFT CITY, GANDHINAGAR, GUJARAT.

Drawing Number: 202210-GBU-AH-S4-EL-002 Revision: North R0

Scale: 1:100 Date: 05/04/24

NOTE:  
 1. Do not scale the drawing  
 2. Only written dimensions and UTM coordinate reference provided to be followed.  
 3. All dimensions are in mm /cm/ m

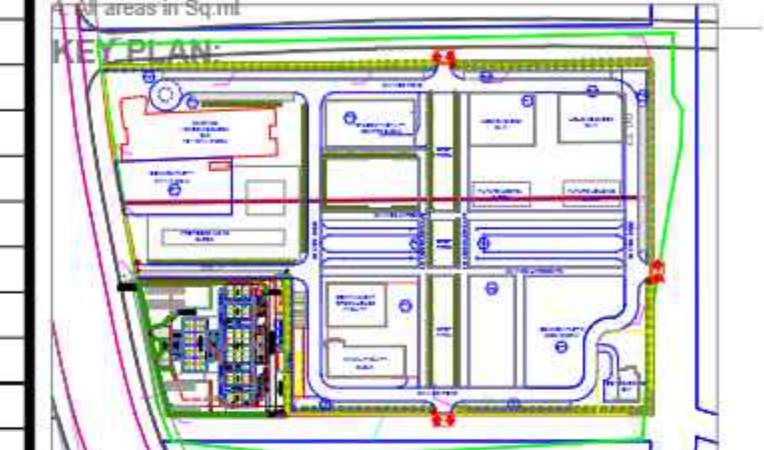


**LEGEND :-**

SYMB	DESCRIPTION
[Symbol]	2 WAY SWITCH BOARD
[Symbol]	SWITCH BOARD
[Symbol]	CEILING FAN
[Symbol]	EXHAUST FAN
[Symbol]	8 W SURFACE / RECESSED LED LIGHT
[Symbol]	12W SURFACE MOUNTED LED LIGHT WITH COVER
[Symbol]	15W RECESSED LED D/L
[Symbol]	15W LED MIRROR LIGHT
[Symbol]	20W LED BATTEN LIGHT (WALL MOUNTED)
[Symbol]	30/40W LED LINEAR LIGHT FITTING
[Symbol]	9W CFL BULKHEAD LIGHT
[Symbol]	100A SWITCH
[Symbol]	30W LED CLEAN ROOM LIGHT FITTING
[Symbol]	38W LED LIGHT FITTING
[Symbol]	INDICATING LIGHT FITTING
[Symbol]	TELEPHONE OUTLET
[Symbol]	COMPUTER POINT
[Symbol]	8A SWITCH SOCKET OUTLET
[Symbol]	2X/8A LIGHT PLUG
[Symbol]	16A SOCKET OUTLET
[Symbol]	30A THREE PHASE SOCKET OUTLET
[Symbol]	MAIN DISTRIBUTION BOARD/UPS
[Symbol]	PDB/UD DISTRIBUTION BOARD
[Symbol]	LIGHT & POWER DISTRIBUTION BOARD
[Symbol]	UPS DISTRIBUTION BOARD
[Symbol]	AHU PANEL
[Symbol]	HEAT DETECTOR
[Symbol]	16A UPS POINT
[Symbol]	FAULT ISOLATOR
[Symbol]	CONTROL MODULE
[Symbol]	FIRE FIGHTER PHONE JACK WITH CONTROL MODULE
[Symbol]	SMOKE DETECTOR AT CEILING / FALSE CEILING
[Symbol]	SMOKE DETECTOR ABOVE / FALSE CEILING
[Symbol]	MANUAL CALL POINT
[Symbol]	HOOTER WITH CONTROL MODULE
[Symbol]	RESPONSE INDICATOR
[Symbol]	MAIN FIRE ALARM PANEL
[Symbol]	FIRE ALARM JUNCTION BOX
[Symbol]	CEILING SPEAKER
[Symbol]	MAIN PA PANEL
[Symbol]	DATA RACK
[Symbol]	DOUBLE CIRCLE SENCER
[Symbol]	DOME CAMERA
[Symbol]	PTZ CAMERA
[Symbol]	BULLET CAMERA
[Symbol]	EXIT LIGHT
[Symbol]	FIRE FIGHTER TELEPHONE

LEGEND:  
 DEVELOPER: GUJARAT BIOTECHNOLOGY UNIVERSITY

ARCHITECT: SURESH GOEL AND ASSOCIATES ARCHITECTS - ENGINEERS - PLANNERS

C-85, SHIVALIK NEW DELHI-110017 TEL:(011)26676254,41034450 MAIL:mail@sgadesignlab.com  
 GIFT Urban Development Authority:

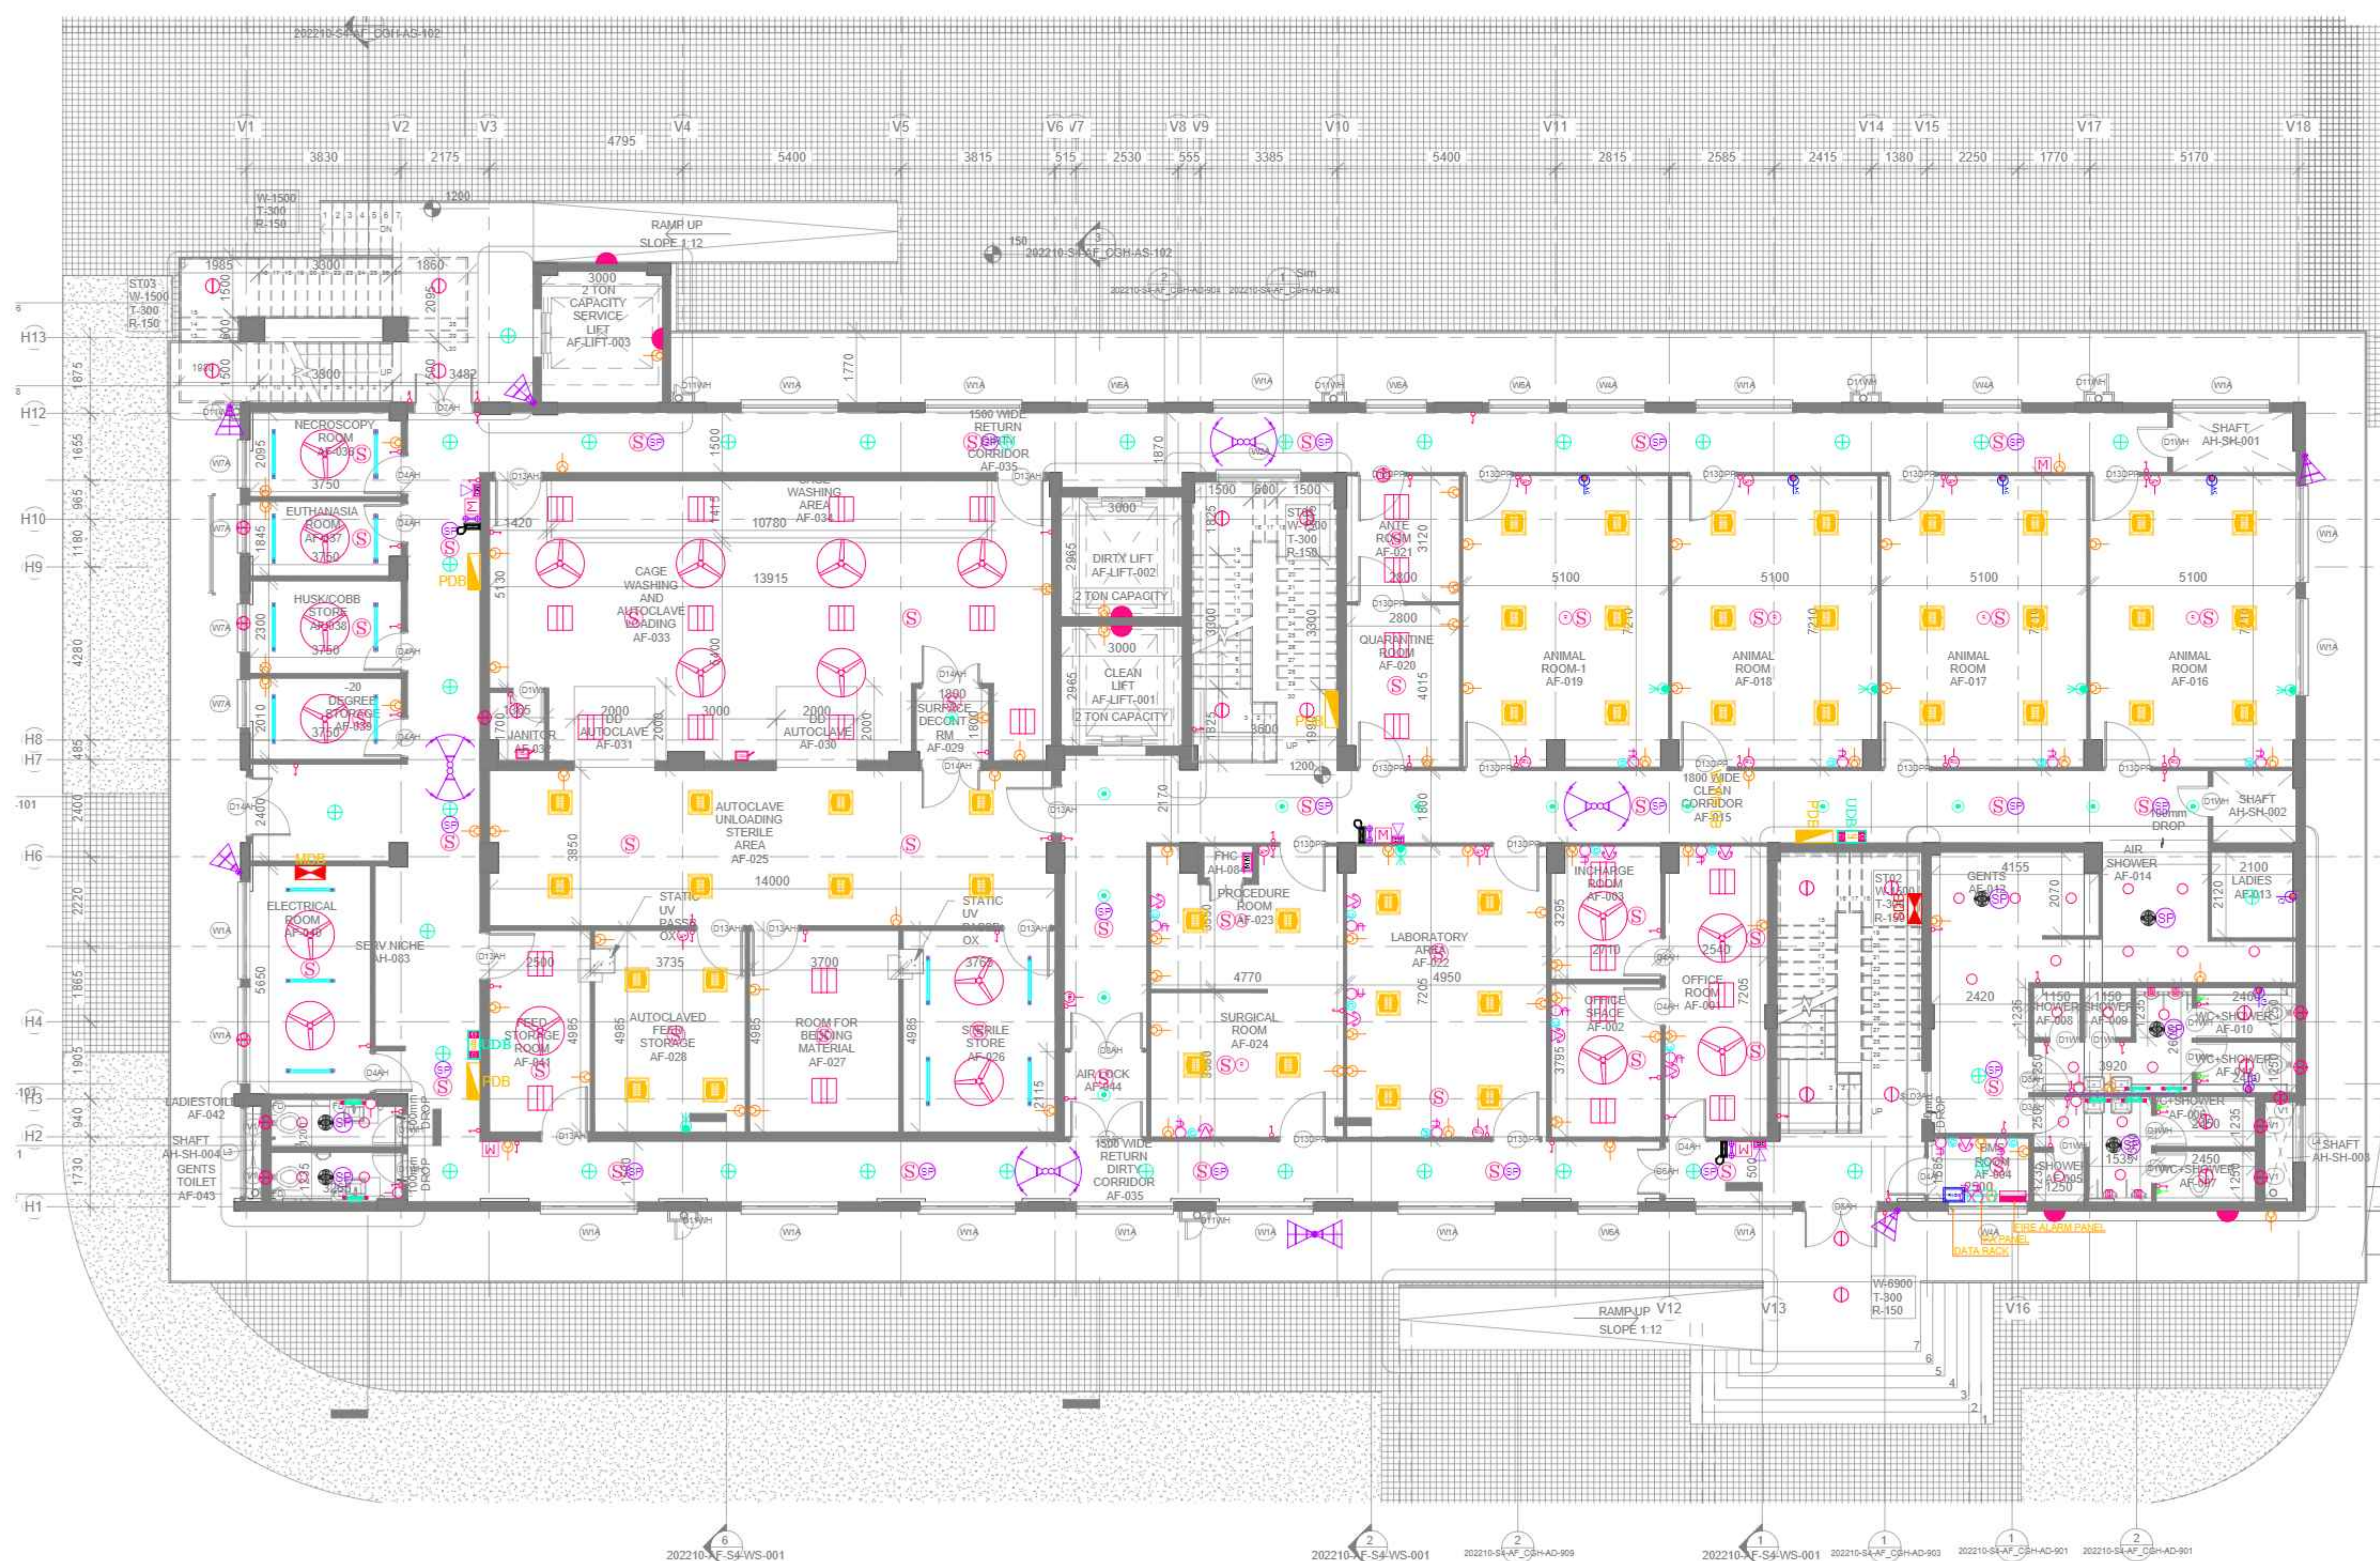




LEGEND :-	
SYMB	DESCRIPTION
	2 WAY SWITCH BOARD
	SWITCH BOARD
	CEILING FAN
	EXHAUST FAN
	6 W SURFACE / RECESSED LED LIGHT
	12 W SURFACE MOUNTED LED LIGHT WITH COVER
	15 W RECESSED LED D/L
	15 W LED MIRROR LIGHT
	20 W LED BATTEN LIGHT (WALL MOUNTED)
	36 W LED LINEAR LIGHT FITTING
	9 W CFL BULKHEAD LIGHT
	100 A SWITCH
	38 W LED CLEAN ROOM LIGHT FITTING
	38 W LED LIGHT FITTING
	INDICATING LIGHT FITTING
	TELEPHONE OUTLET
	COMPUTER POINT
	8 A SWITCH SOCKET OUTLET
	2 X 8 A LIGHT PLUG
	16 A SOCKET OUTLET
	30 A THREE PHASE SOCKET OUTLET
	MAIN DISTRIBUTION BOARD UPS
	FDB-U DISTRIBUTION BOARD
	LIGHT & POWER DISTRIBUTION BOARD
	UPS DISTRIBUTION BOARD
	AHU PANEL
	HEAT DETECTOR
	16 A UPS POINT
	FAULT ISOLATOR
	CONTROL MODULE
	FIRE FIGHTER PHONE JACK WITH CONTROL MODULE
	SMOKE DETECTOR AT CEILING / FALSE CEILING
	SMOKE DETECTOR ABOVE / FALSE CEILING
	MANUAL CALL POINT
	HOOTER WITH CONTROL MODULE
	RESPONSE INDICATOR
	MAIN FIRE ALARM PANEL
	FIRE ALARM JUNCTION BOX
	CEILING SPEAKER
	MAIN PA PANEL
	DATA RACK
	DOUBLE CIRCLE SENCER
	DOME CAMERA
	PTZ CAMERA
	BULLET CAMERA
	EXIT LIGHT
	FIRE FIGHTER TELEPHONE

ISSUED FOR: TENDER PURPOSE SHEET NO. 1

Drawing Title: ANIMAL FACILITY BLOCK  
 Project Title: GUJARAT BIOTECHNOLOGY UNIVERSITY, GIFT CITY, GANDHINAGAR, GUJARAT.

Drawing Number: 202210-GBU-AH-64-EL-003  
 Scale: 1:100  
 Date: 05/04/24

NOTE:  
 1. Do not scale the drawing  
 2. Only written dimensions and UTM coordinate reference provided to be followed.  
 3. All dimensions are in mm /cm / m

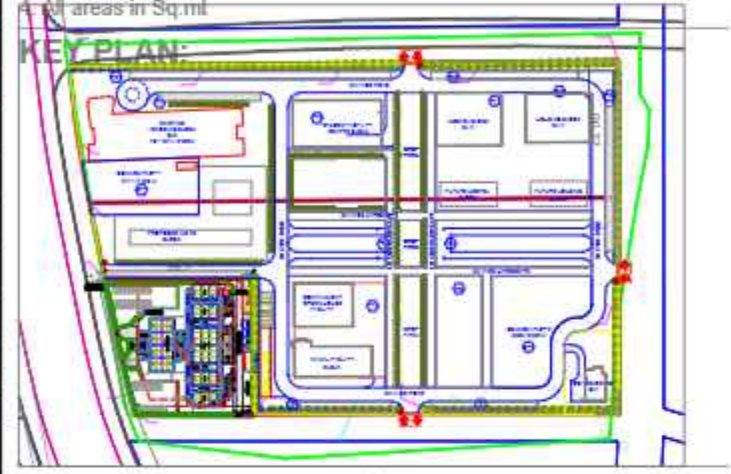

LEGEND:  
 DEVELOPER: GUJARAT BIOTECHNOLOGY UNIVERSITY

ARCHITECT: SURESH GOEL AND ASSOCIATES ARCHITECTS - ENGINEERS - PLANNERS

C-85, SHIVALIK NEW DELHI-110017  
 TEL:(011)26676254,41034450  
 MAIL:mail@sgadesignlab.com  
 GIFT Urban Development Authority:






LEGEND :-	
SYMB	DESCRIPTION
	2 WAY SWITCH BOARD
	SWITCH BOARD
	CEILING FAN
	EXHAUST FAN
	6 W SURFACE / RECESSED LED LIGHT
	12W SURFACE MOUNTED LED LIGHT WITH COVER
	15W RECESSED LED DIL
	15W LED MIRROR LIGHT
	20W LED BATTEN LIGHT (WALL MOUNTED)
	3640W LED LINEAR LIGHT FITTING
	9W CFL BULKHEAD LIGHT
	100A SWITCH
	38W LED CLEAN ROOM LIGHT FITTING
	38W LED LIGHT FITTING
	INDICATING LIGHT FITTING
	TELEPHONE OUTLET
	COMPUTER POINT
	8A SWITCH SOCKET OUTLET
	2X8A LIGHT PLUG
	16A SOCKET OUTLET
	30A THREE PHASE SOCKET OUTLET
	MAIN DISTRIBUTION BOARD UPS
	FDB-U DISTRIBUTION BOARD
	LIGHT & POWER DISTRIBUTION BOARD
	UPS DISTRIBUTION BOARD
	AHU PANEL
	HEAT DETECTOR
	16A UPS POINT
	FAULT ISOLATOR
	CONTROL MODULE
	FIRE FIGHTER PHONE JACK WITH CONTROL MODULE
	SMOKE DETECTOR AT CEILING / FALSE CEILING
	SMOKE DETECTOR ABOVE / FALSE CEILING
	MANUAL CALL POINT
	HOOTER WITH CONTROL MODULE
	RESPONSE INDICATOR
	MAIN FIRE ALARM PANEL
	FIRE ALARM JUNCTION BOX
	CEILING SPEAKER
	MAIN PA PANEL
	DATA RACK
	DOUBLE CIRCLE SENCER
	DOME CAMERA
	PTZ CAMERA
	BULLET CAMERA
	EXIT LIGHT
	FIRE FIGHTER TELEPHONE

ISSUED FOR: TENDER PURPOSE SHEET NO. 1

Drawing Title: ANIMAL FACILITY BLOCK  
 Project Title: GUJARAT BIOTECHNOLOGY UNIVERSITY, GIFT CITY, GANDHINAGAR, GUJARAT.

Drawing Number: 202210-GBU-AH-64-EL-004  
 Revision: North  
 Scale: 1:100  
 Date: 05/04/24


NOTE:  
 1. Do not scale the drawing  
 2. Only written dimensions and UTM coordinate reference provided to be followed.  
 3. All dimensions are in mm /cm/ m

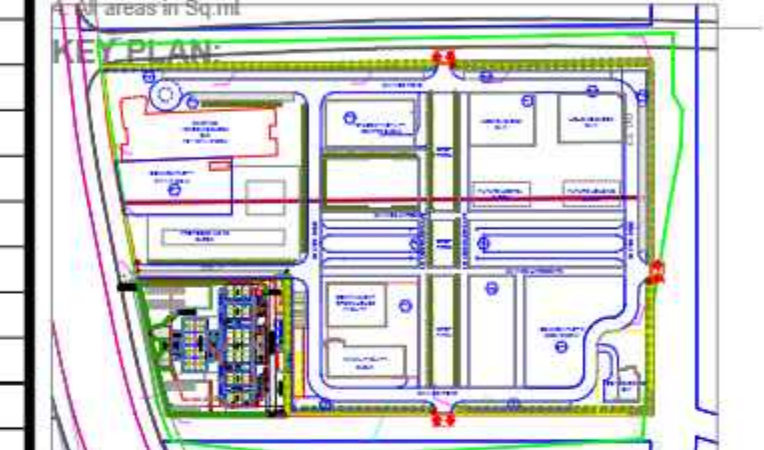

LEGEND:  
 DEVELOPER: GUJARAT BIOTECHNOLOGY UNIVERSITY

ARCHITECT: SURESH GOEL AND ASSOCIATES ARCHITECTS - ENGINEERS - PLANNERS

C-85, SHIVALIK NEW DELHI-110017  
 TEL:(011)26676254,41034450  
 MAIL:mail@sgadesignlab.com  
 GIFT Urban Development Authority:

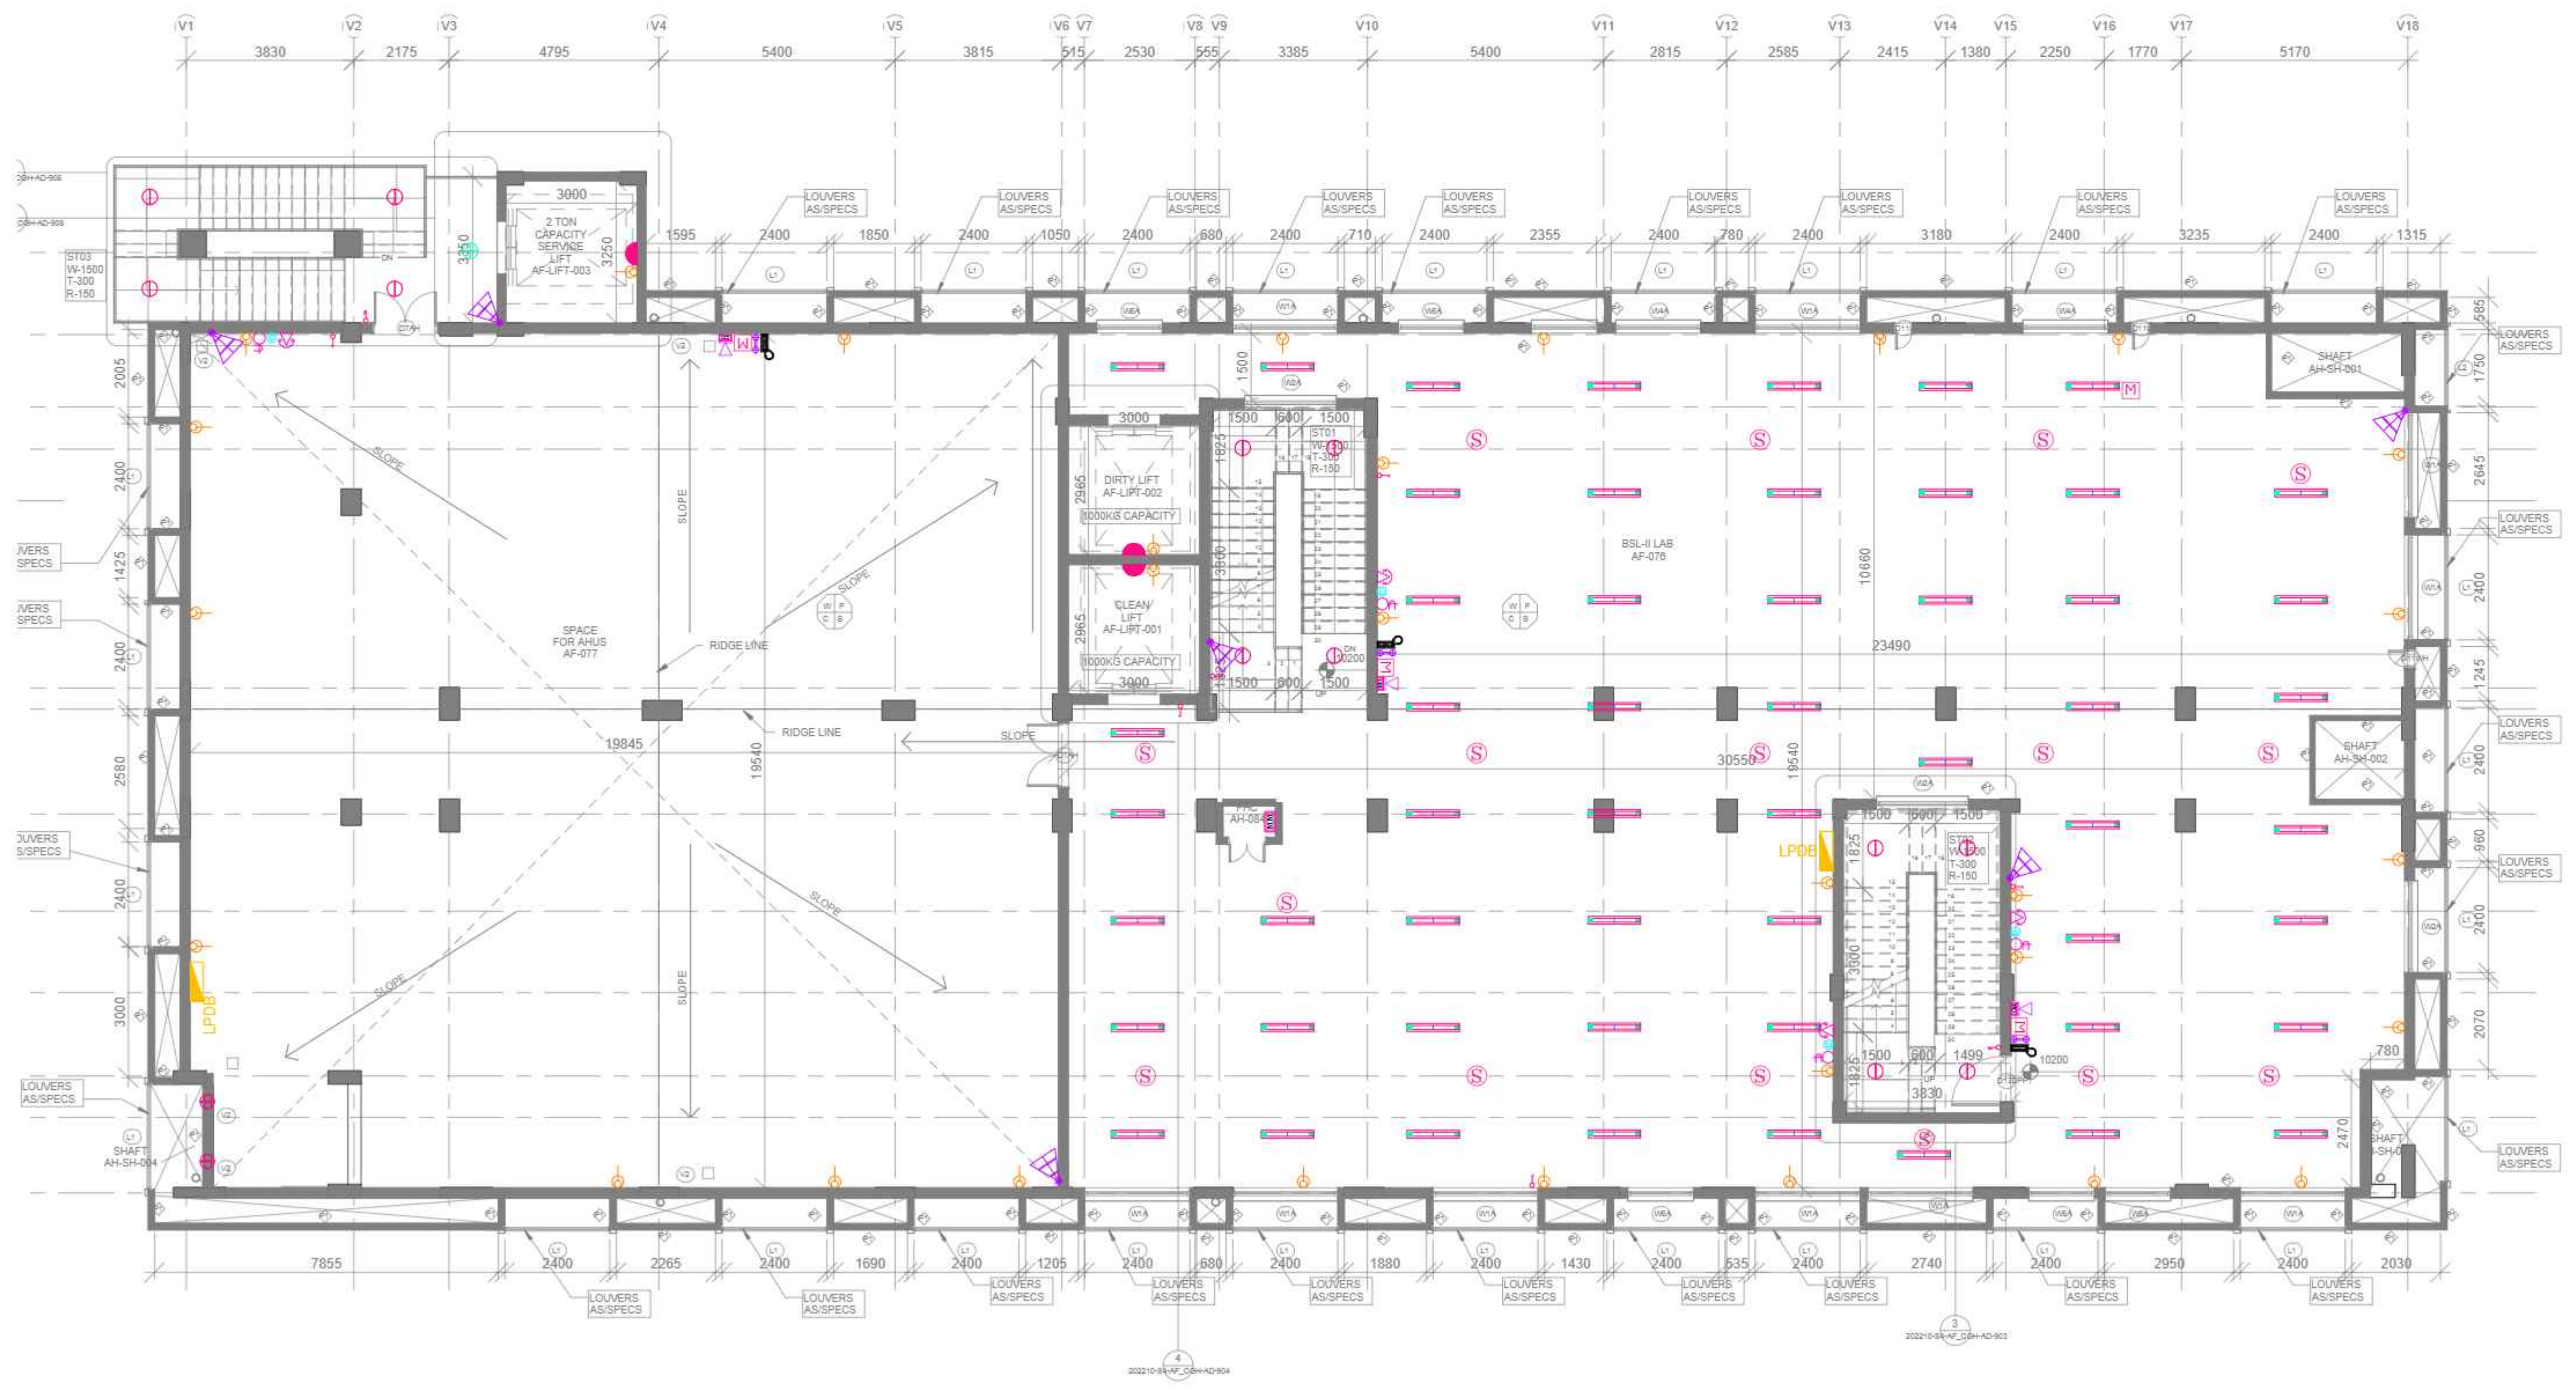



LEGEND :-	
SYMB	DESCRIPTION
	2 WAY SWITCH BOARD
	SWITCH BOARD
	CEILING FAN
	EXHAUST FAN
	6 W SURFACE / RECESSED LED LIGHT
	12W SURFACE MOUNTED LED LIGHT WITH COVER
	15W RECESSED LED DIL
	15W LED MIRROR LIGHT
	20W LED BATTEN LIGHT (WALL MOUNTED)
	36/40W LED LINEAR LIGHT FITTING
	9W CFL BULKHEAD LIGHT
	100A SWITCH
	38W LED CLEAN ROOM LIGHT FITTING
	38W LED LIGHT FITTING
	INDICATING LIGHT FITTING
	TELEPHONE OUTLET
	COMPUTER POINT
	8A SWITCH SOCKET OUTLET
	2X8A LIGHT PLUG
	16A SOCKET OUTLET
	30A THREE PHASE SOCKET OUTLET
	MAIN DISTRIBUTION BOARD UPS
	FDB-U DISTRIBUTION BOARD
	LIGHT & POWER DISTRIBUTION BOARD
	UPS DISTRIBUTION BOARD
	AHU PANEL
	HEAT DETECTOR
	16A UPS POINT
	FAULT ISOLATOR
	CONTROL MODULE
	FIRE FIGHTER PHONE JACK WITH CONTROL MODULE
	SMOKE DETECTOR AT CEILING / FALSE CEILING
	SMOKE DETECTOR ABOVE / FALSE CEILING
	MANUAL CALL POINT
	HOOTER WITH CONTROL MODULE
	RESPONSE INDICATOR
	MAIN FIRE ALARM PANEL
	FIRE ALARM JUNCTION BOX
	CEILING SPEAKER
	MAIN PA PANEL
	DATA RACK
	DOUBLE CIRCLE SENCER
	DOME CAMERA
	PTZ CAMERA
	BULLET CAMERA
	EXIT LIGHT
	FIRE FIGHTER TELEPHONE

ISSUED FOR: TENDER PURPOSE SHEET NO. 1

Drawing Title: ANIMAL FACILITY BLOCK

TERRACE FLOOR ELECTRICAL LAYOUT

Project Title: GUJARAT BIOTECHNOLOGY UNIVERSITY, GIFT CITY, GANDHINAGAR, GUJARAT.

Drawing Number: 202210-GBU-AH-64-EL-005 Revision: R0 North

Scale: 1:100 Date: 05/04/24

NOTE:

- Do not scale the drawing
- Only written dimensions and UTM coordinate reference provided to be followed.
- All dimensions are in mm /cm/ m


LEGEND:

DEVELOPER: GUJARAT BIOTECHNOLOGY UNIVERSITY

ARCHITECT: SURESH GOEL AND ASSOCIATES ARCHITECTS - ENGINEERS - PLANNERS

C-85, SHIVALIK NEW DELHI-110017 TEL:(011)26676254,41034450 MAIL:mail@sgadesignlab.com

GIFT Urban Development Authority:

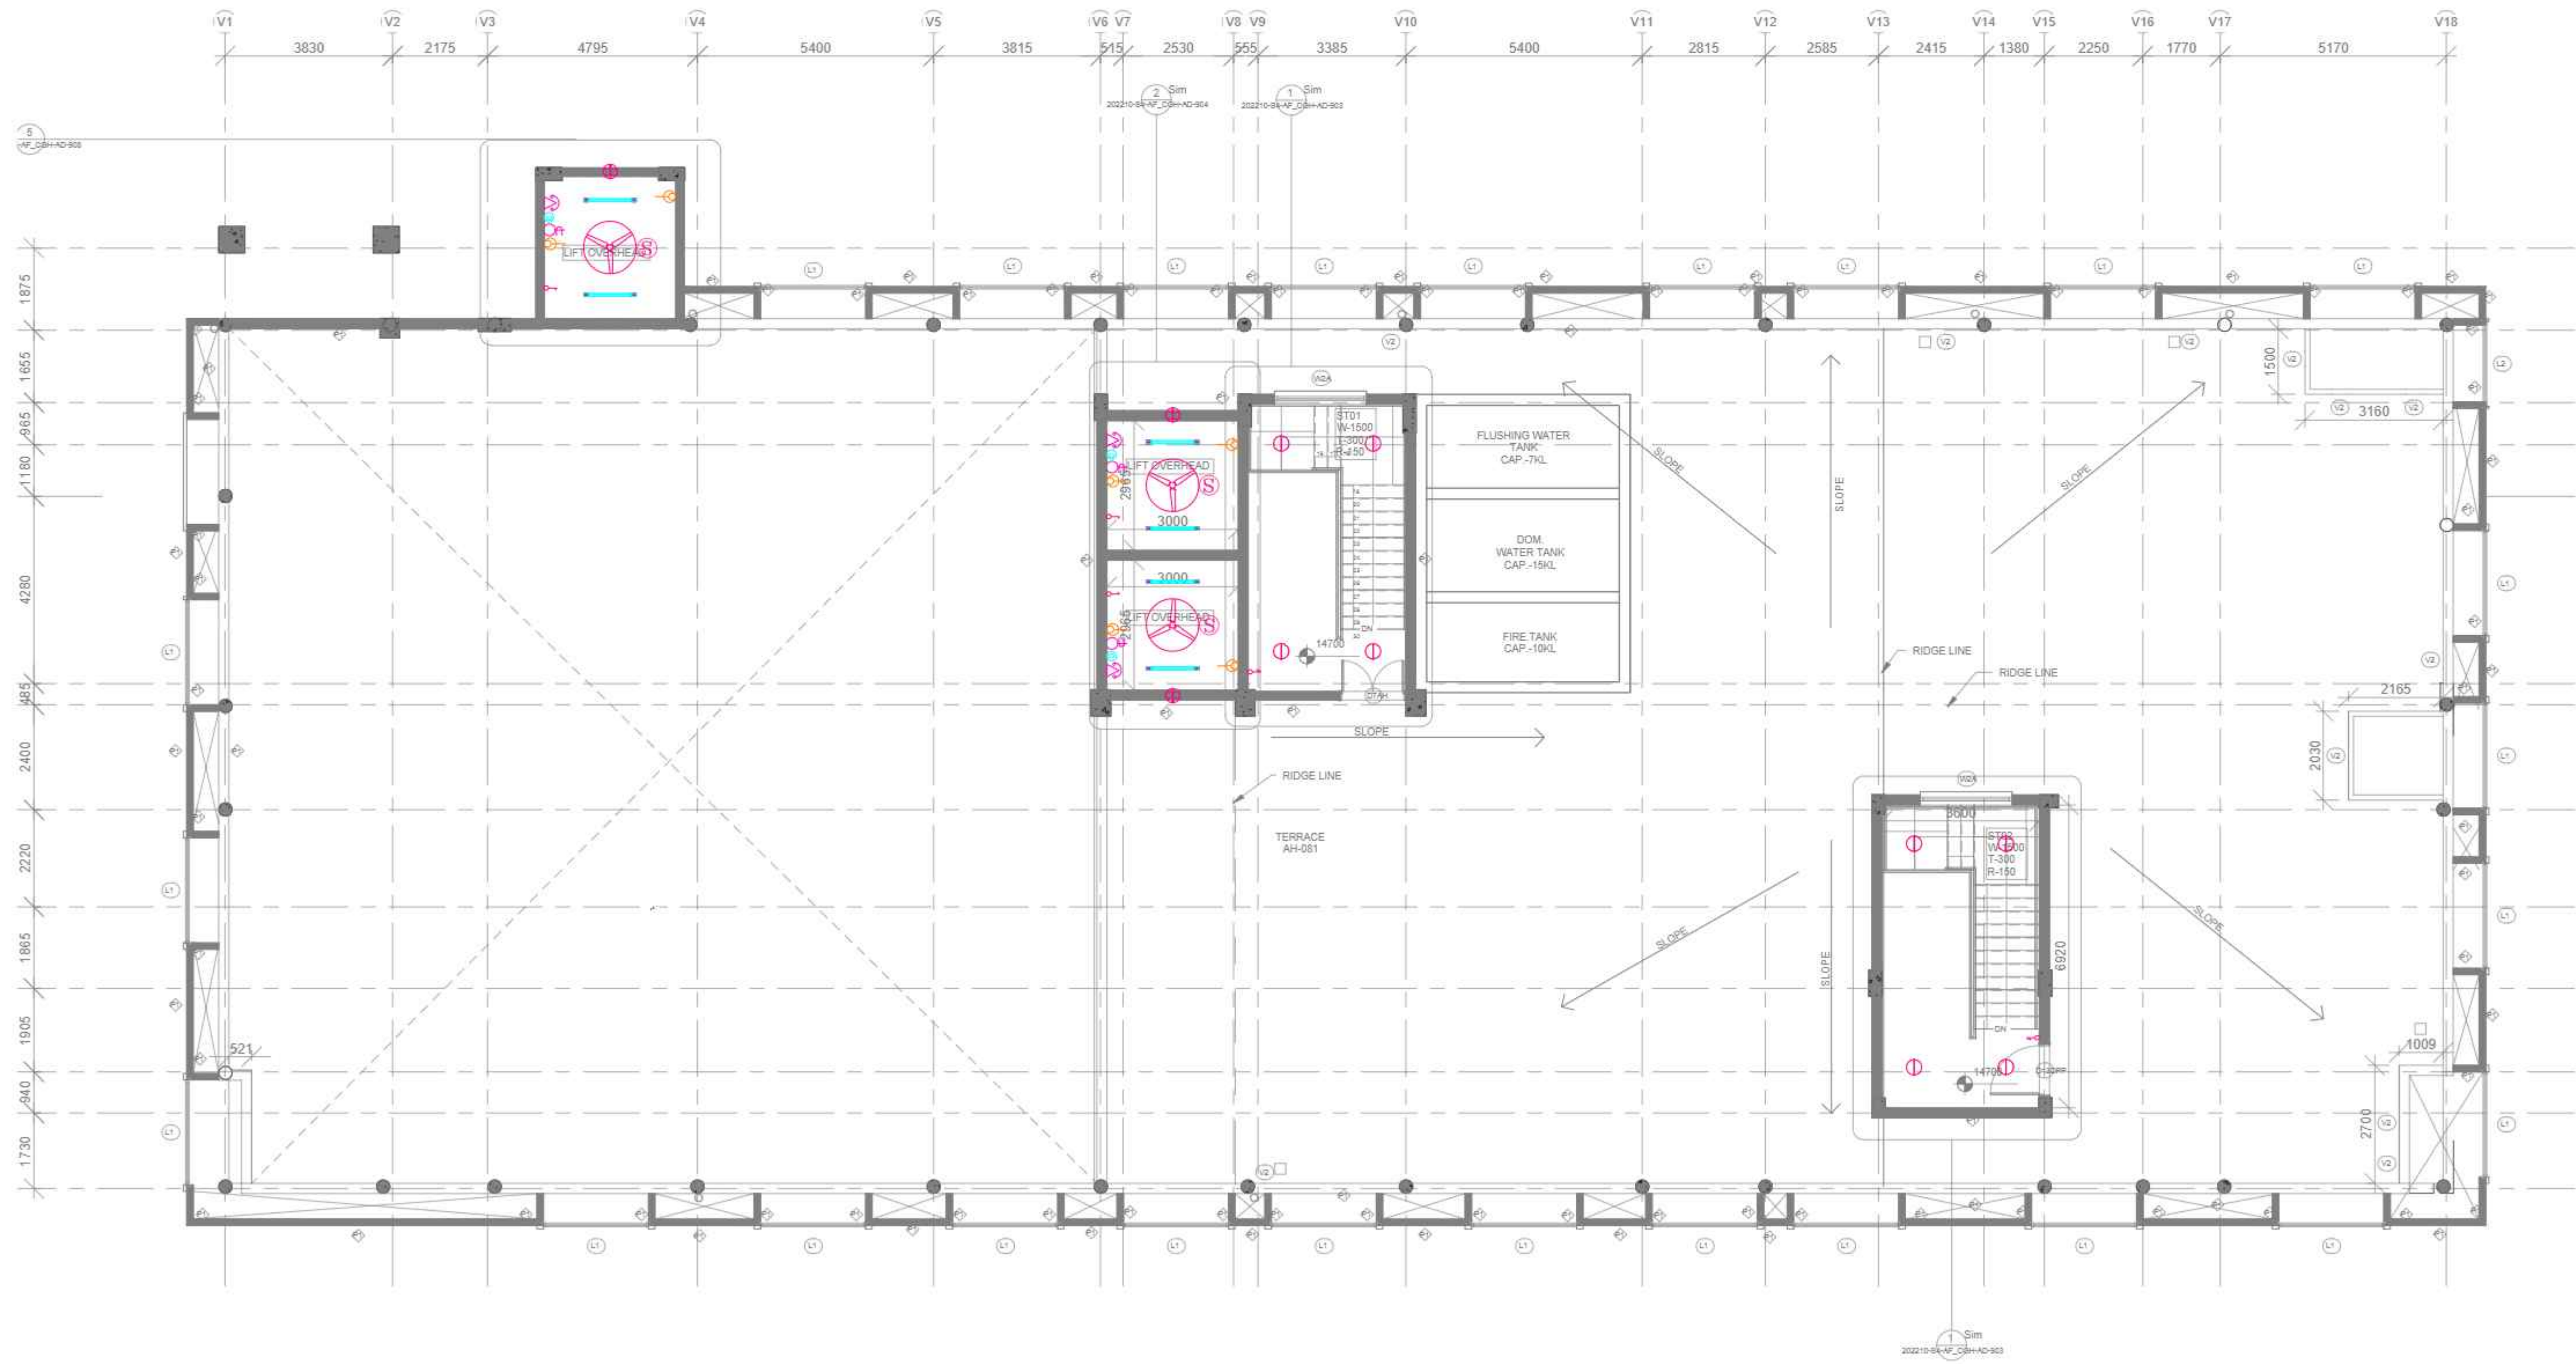





**LEGEND :-**

SYMB	DESCRIPTION
[Symbol]	2 WAY SWITCH BOARD
[Symbol]	SWITCH BOARD
[Symbol]	20W LED BATTEN LIGHT (WALL MOUNTED)
[Symbol]	20W LED BATTEN LIGHT (CEILING MOUNTED)
[Symbol]	36/40W LED LINEAR LIGHT FITTING
[Symbol]	MDB DISTRIBUTION BOARD (E)
[Symbol]	MDB DISTRIBUTION BOARD (N)
[Symbol]	MDB DISTRIBUTION BOARD (AHU)
[Symbol]	MDB DISTRIBUTION BOARD (AC)
[Symbol]	16A SWITCH SOCKET OUTLET
[Symbol]	600W LED PAR LIGHT FITTING
[Symbol]	LPDB DISTRIBUTION BOARD
[Symbol]	LIGHT DISTRIBUTION BOARD
[Symbol]	PDB DISTRIBUTION BOARD
[Symbol]	15W LED LIGHT

**ISSUED FOR :**  
TENDER  
PURPOSE

**SHEET NO.**  
1

Drawing Title:  
GREEN HOUSE

Project Title:  
GUJARAT BIOTECHNOLOGY UNIVERSITY,  
GIFT CITY, GANDHINAGAR, GUJARAT.

Drawing Number:  
202210-GBU-GH-04-EL-001

Revision: North  
R0

Scale:  
1:100

Date:  
05/04/24

**NOTE:**

- Do not scale the drawing
- Only written dimensions and UTM coordinate reference provided to be followed.
- All dimensions are in mm /cm/ m

202210-SLAF-CGHEAD-907

**LEGEND:**

**DEVELOPER:**  
GUJARAT BIOTECHNOLOGY UNIVERSITY

**ARCHITECT:**  
SURESH GOEL AND ASSOCIATES  
ARCHITECTS - ENGINEERS - PLANNERS

C-85, SHIVALIK  
NEW DELHI-110017  
TEL(011)26676254,41034450  
MAIL:mail@sgadesignlab.com

GIFT Urban Development Authority: