


HVAC LEGEND		
01		C.S.U UNIT
02		DOUBLE SKIN H.R.W.
03		VENTILATION LINE FAN
04		CHW RETURN PIPE
05		CHW SUPPLY PIPE
06		SUPPLY AIR DUCT
07		EXHAUST AIR DUCT

KEY PLAN:

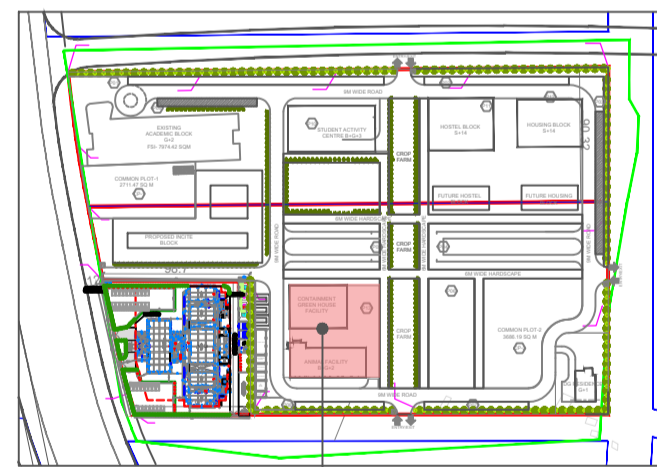

ANIMAL HOUSE CONTAINMENT GREEN HOUSE



NOTE - ONLY FOR TENDER PURPOSE

DATE	REV	REV BY	DESCRIPTION	DATE	NO	ISSUED TO

**ARCHITECT**  
SURESH GOEL AND ASSOCIATES  
ARCHITECTS . ENGINEERS . PLANNERS

DWG ISSUE/NO	DN - 16-05-2024	AT - NEW DELHI	PROJECT CODE
NO	NO	NO	202210

ORIGINATED BY	CHECKED BY	VALIDATED BY	BUILDING CODE
Name : S.K	Name : R.SINGH	Name : R.SINGH	AF

**PROJECT:**  
GUJARAT BIOTECHNOLOGY UNIVERSITY

C-85, SHIVALIK  
NEW DELHI-110017  
TEL:(011)26676254,41034450  
MAIL:mail@sgadesignlab.com

FOR TENDER PURPOSE ONLY CLIENT :


**BUILDING TYPE:**  
ANIMAL HOUSE & CONTAINMENT GREEN HOUSE

**DRAWING TITLE:**  
BASEMENT\_FLOOR\_HVAC\_PLAN


**DRAWING NUMBER:**  
202210-AH-S4-HV-001

REVISION

SCALE: 1:100 SHEET SIZE: A3 SHEET NO:

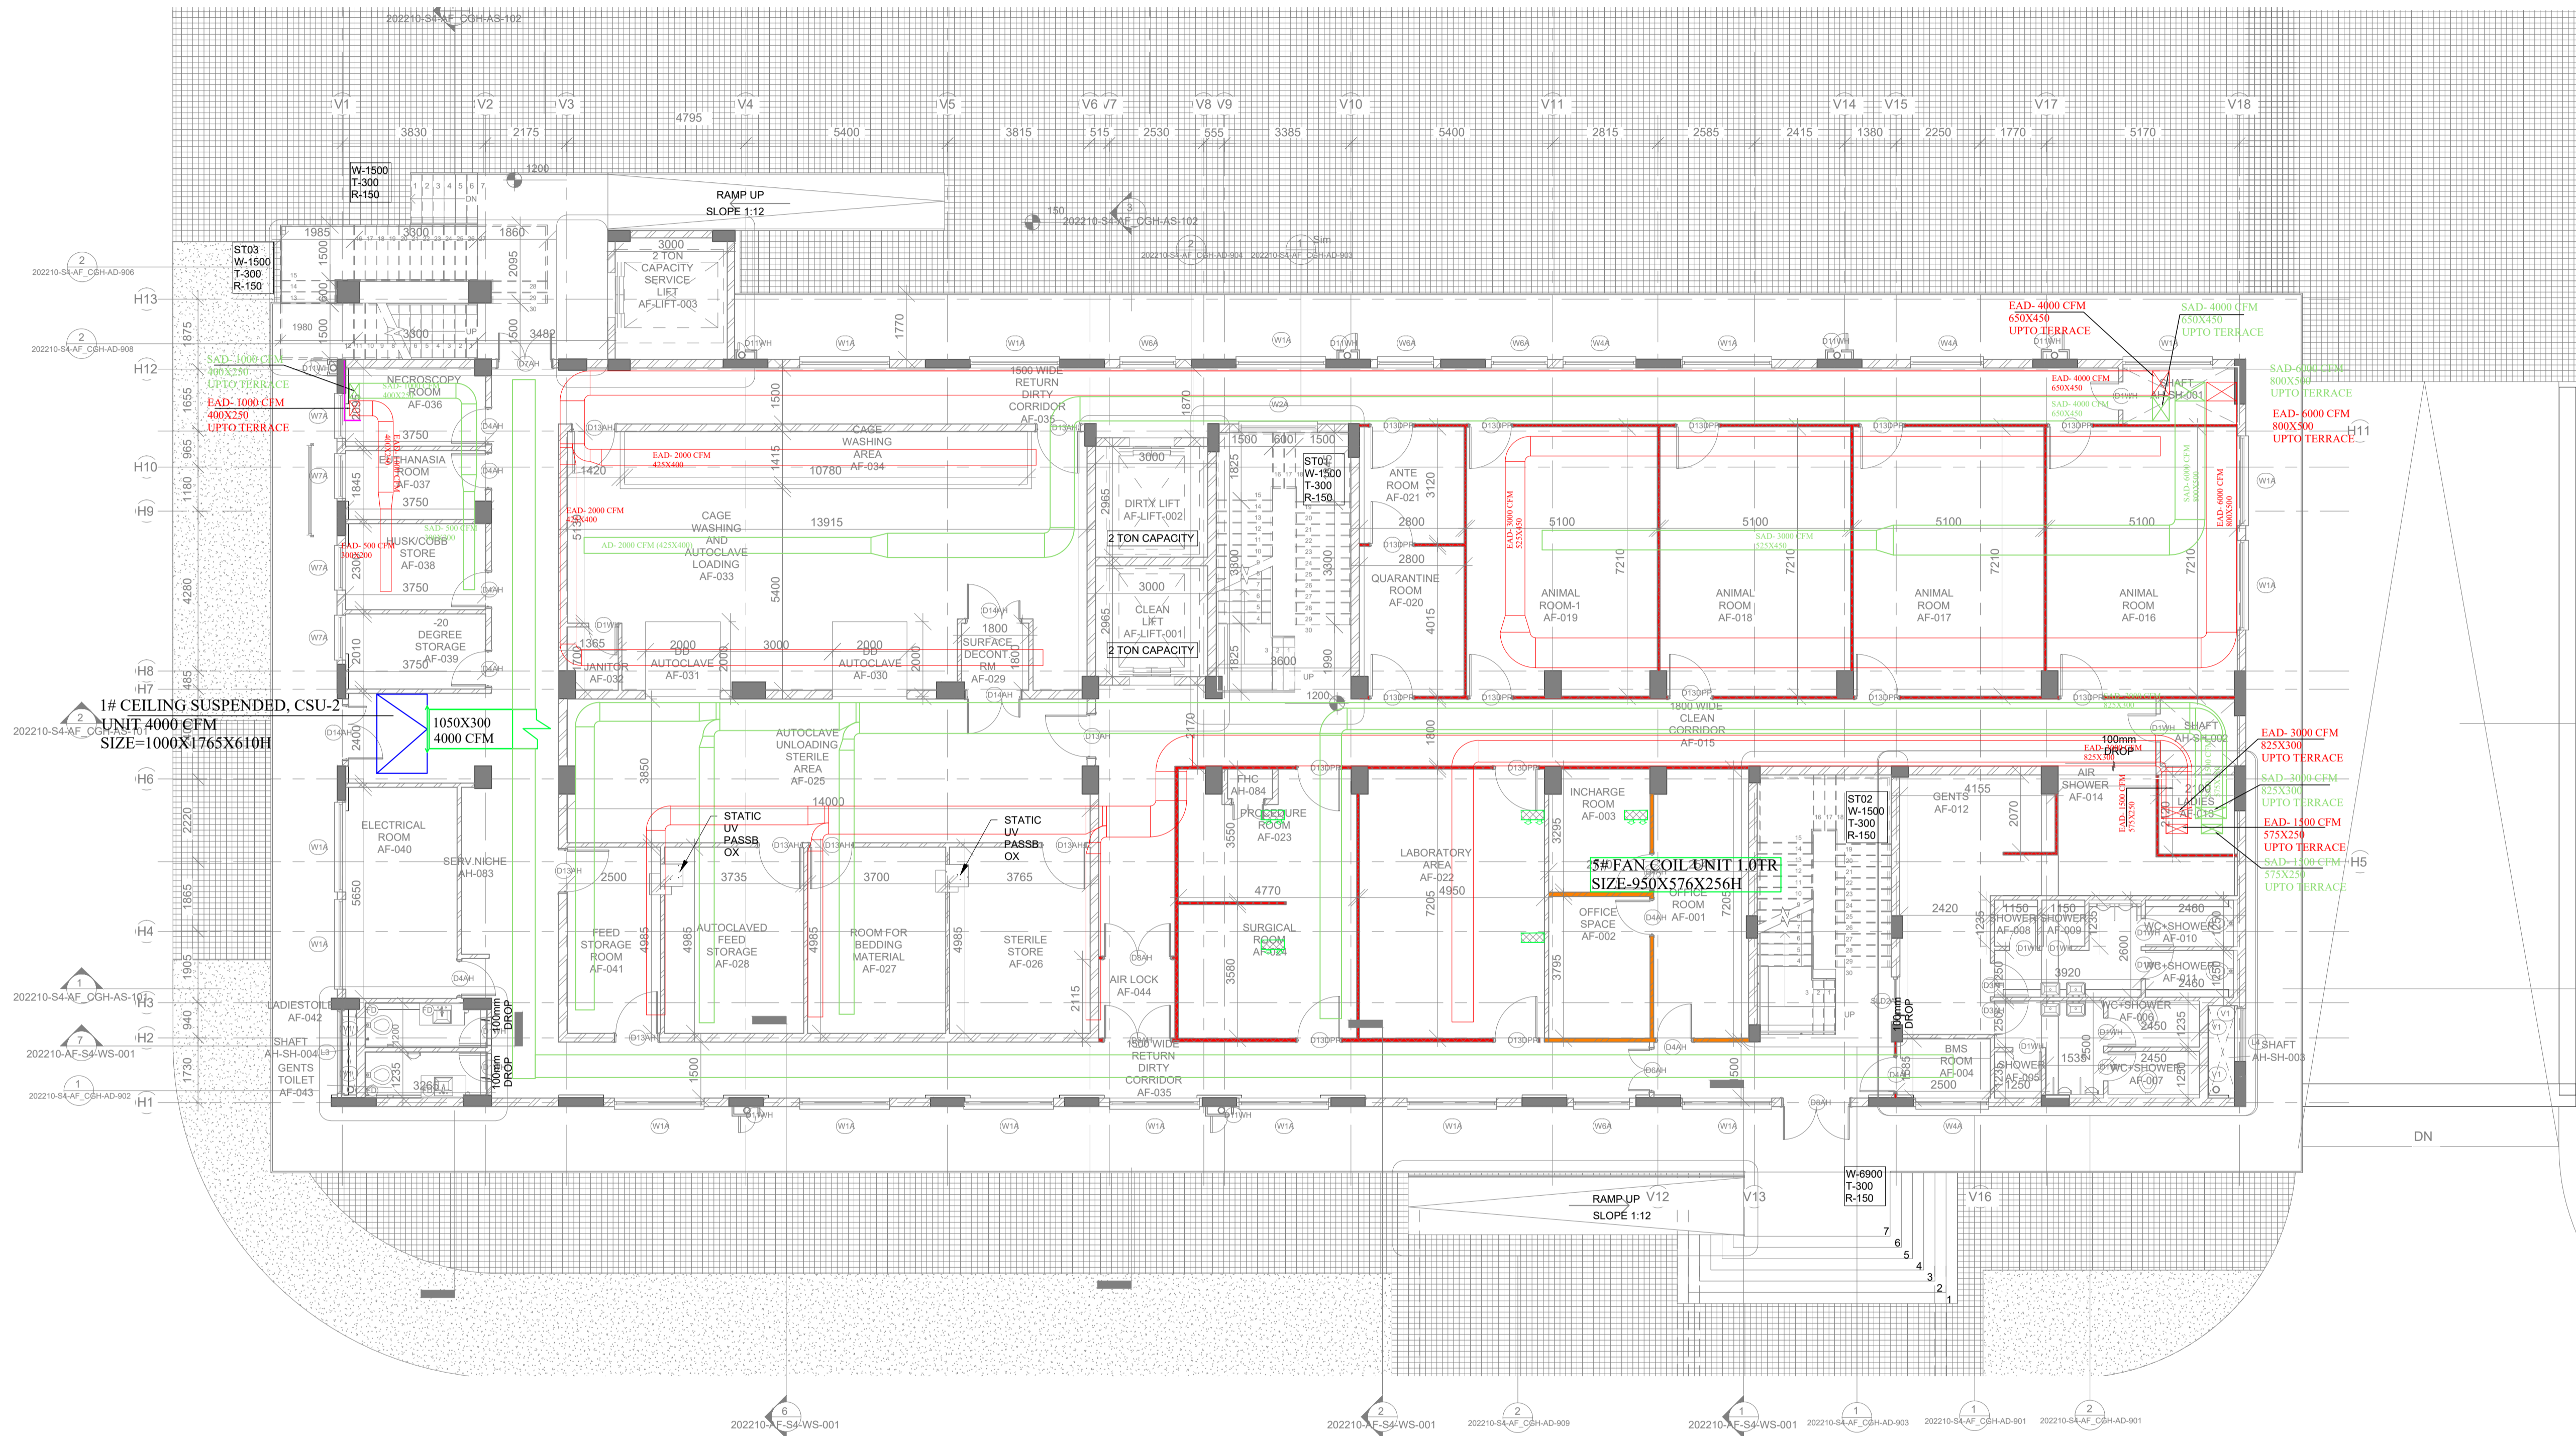

KEY PLAN:

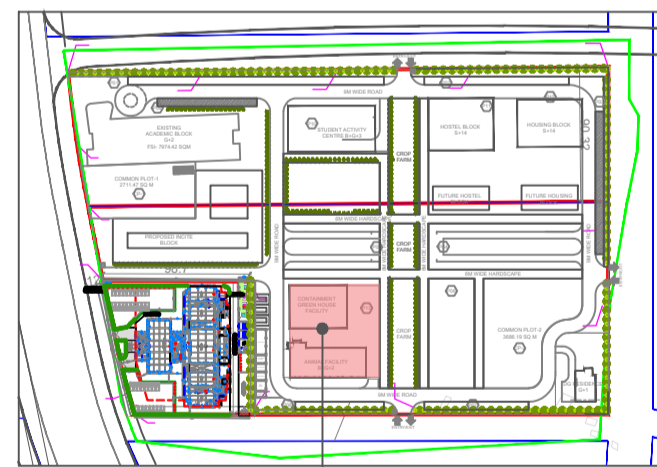

HVAC LEGEND		
01		C.S.U UNIT
02		DOUBLE SKIN H.R.W.
03		VENTILATION LINE FAN
04		CHW RETURN PIPE
05		CHW SUPPLY PIPE
06		SUPPLY AIR DUCT
07		EXHAUST AIR DUCT



NOTE - ONLY FOR TENDER PURPOSE

DATE	REV	REV BY	DESCRIPTION	DATE	NO	ISSUED TO

**ARCHITECT**  
**SURESH GOEL AND ASSOCIATES**  
 ARCHITECTS . ENGINEERS . PLANNERS


DWG NO	ISSUED ON	BY	AT	PROJECT CODE
202210-S4-AF-CGH-AD-002	16-05-2024		NEW DELHI	202210

ORIGINATED BY	CHECKED BY	ENGINEER	VALIDATED BY	ENGINEER	BUILDING CODE
Name : S.K	Name : R.SINGH	Name : R.SINGH			AF


**PROJECT:**  
 GUJARAT BIOTECHNOLOGY UNIVERSITY

<p>C-85, SHIVALIK          NEW DELHI-110017          TEL:(011)26676254,41034450          MAIL:mail@sgadesignlab.com</p>	CLIENT :
	FOR TENDER PURPOSE ONLY

<p>SCALE: 1:100</p>	<b>BUILDING TYPE:</b> ANIMAL HOUSE & CONTAINMENT GREEN HOUSE
	<b>DRAWING TITLE:</b> GROUND FLOOR HVAC PLAN AH
	<b>DRAWING NUMBER:</b> 202210-AH-S4-HV-002
	REVISION SHEET NO:

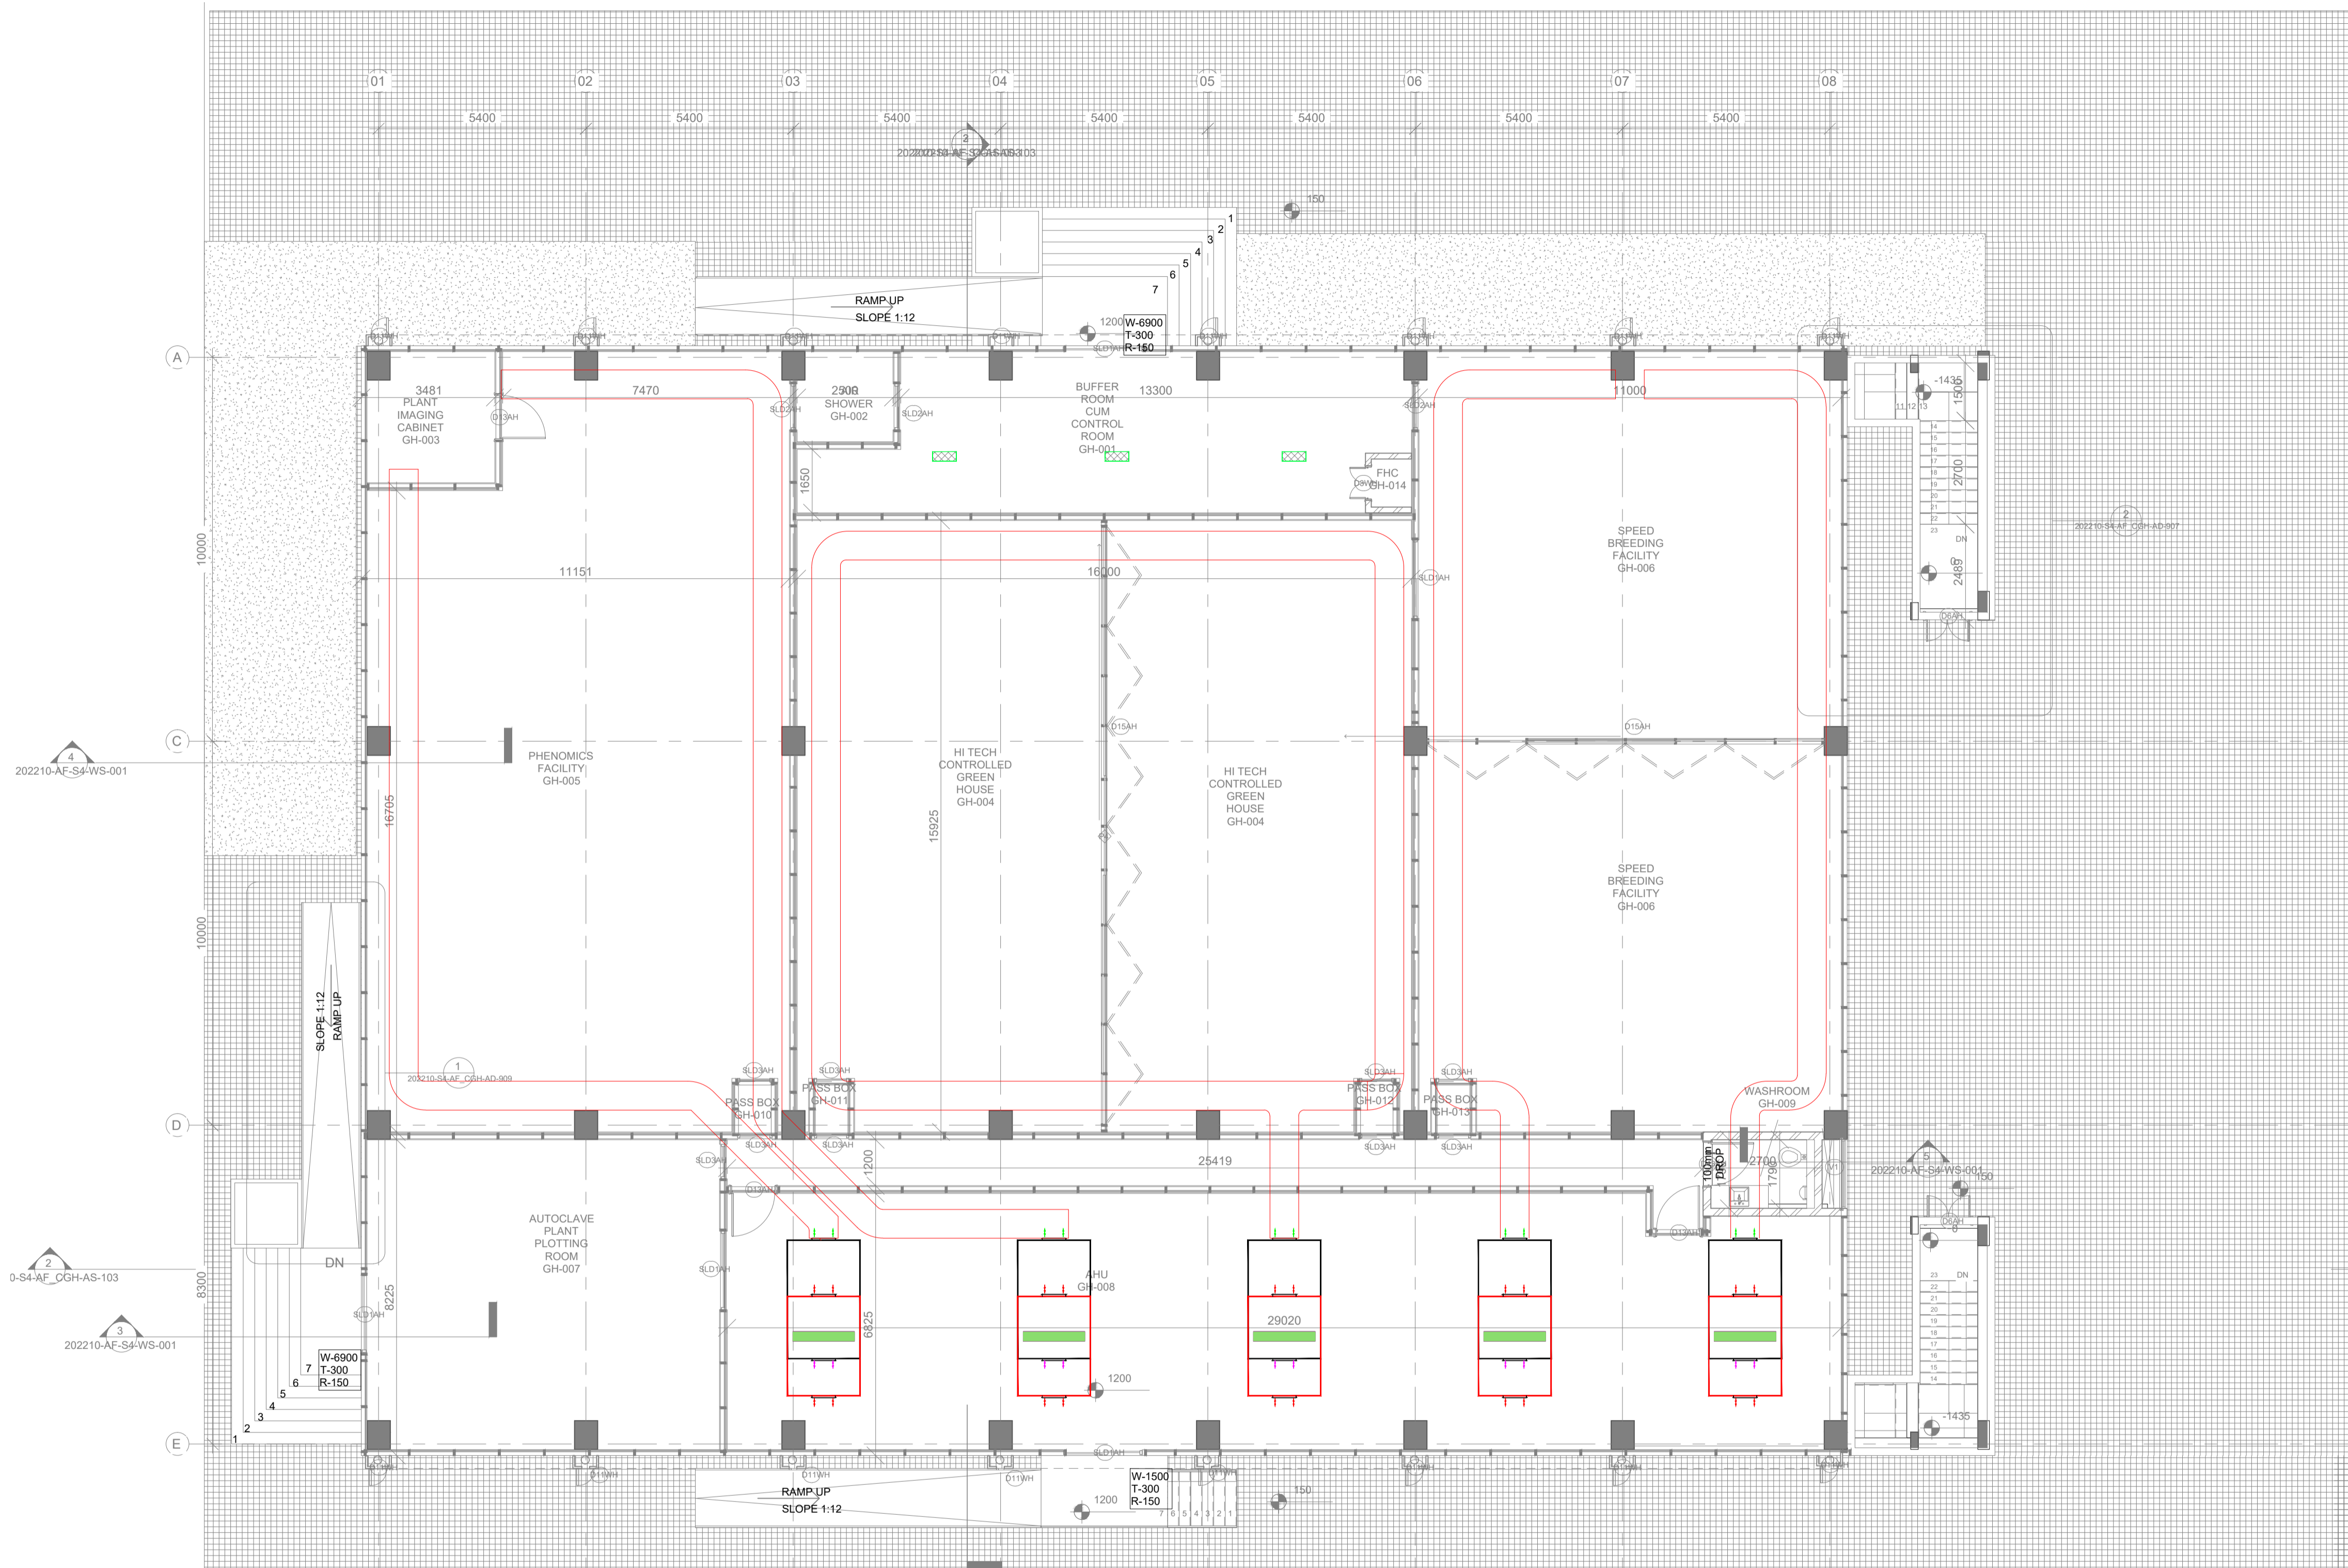

KEY PLAN:

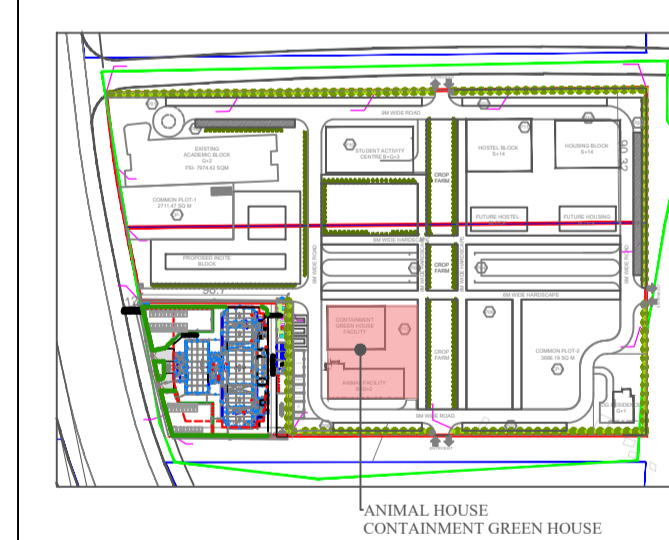

HVAC LEGEND		
01		C.S.U UNIT
02		DOUBLE SKIN H.R.W.
03		VENTILATION LINE FAN
04		CHW RETURN PIPE
05		CHW SUPPLY PIPE
06		SUPPLY AIR DUCT
07		EXHAUST AIR DUCT



NOTE - ONLY FOR TENDER PURPOSE

DATE	REV	REV BY	DESCRIPTION	DATE	NO	ISSUED TO

**ARCHITECT**  
**SURESH GOEL AND ASSOCIATES**  
 ARCHITECTS . ENGINEERS . PLANNERS

DWG ISSUED ON	BY	AT	PROJECT CODE
16-05-2024	SG	NEW DELHI	202210


ORIGINATED BY	CHECKED BY	ENGINEER	VALIDATED BY	ENGINEER	BUILDING CODE
Name : S.K	Name : R.SINGH	Name : R.SINGH			AF

**PROJECT:**  
 GUJARAT BIOTECHNOLOGY UNIVERSITY

 C-85, SHIVALIK NEW DELHI-110017 TEL:(011)26676254,41034450 MAIL:mail@sagadesignlab.com	CLIENT :
---	----------

FOR TENDER PURPOSE ONLY

BUILDING TYPE:	REVISION
ANIMAL HOUSE & CONTAINMENT GREEN HOUSE	
<b>DRAWING TITLE:</b> GROUND_FLOOR_HVAC_PLAN_CGH	
<b>DRAWING NUMBER:</b> 202210-AH-S4-HV-003	
SCALE: 1:100	SHEET NO.:

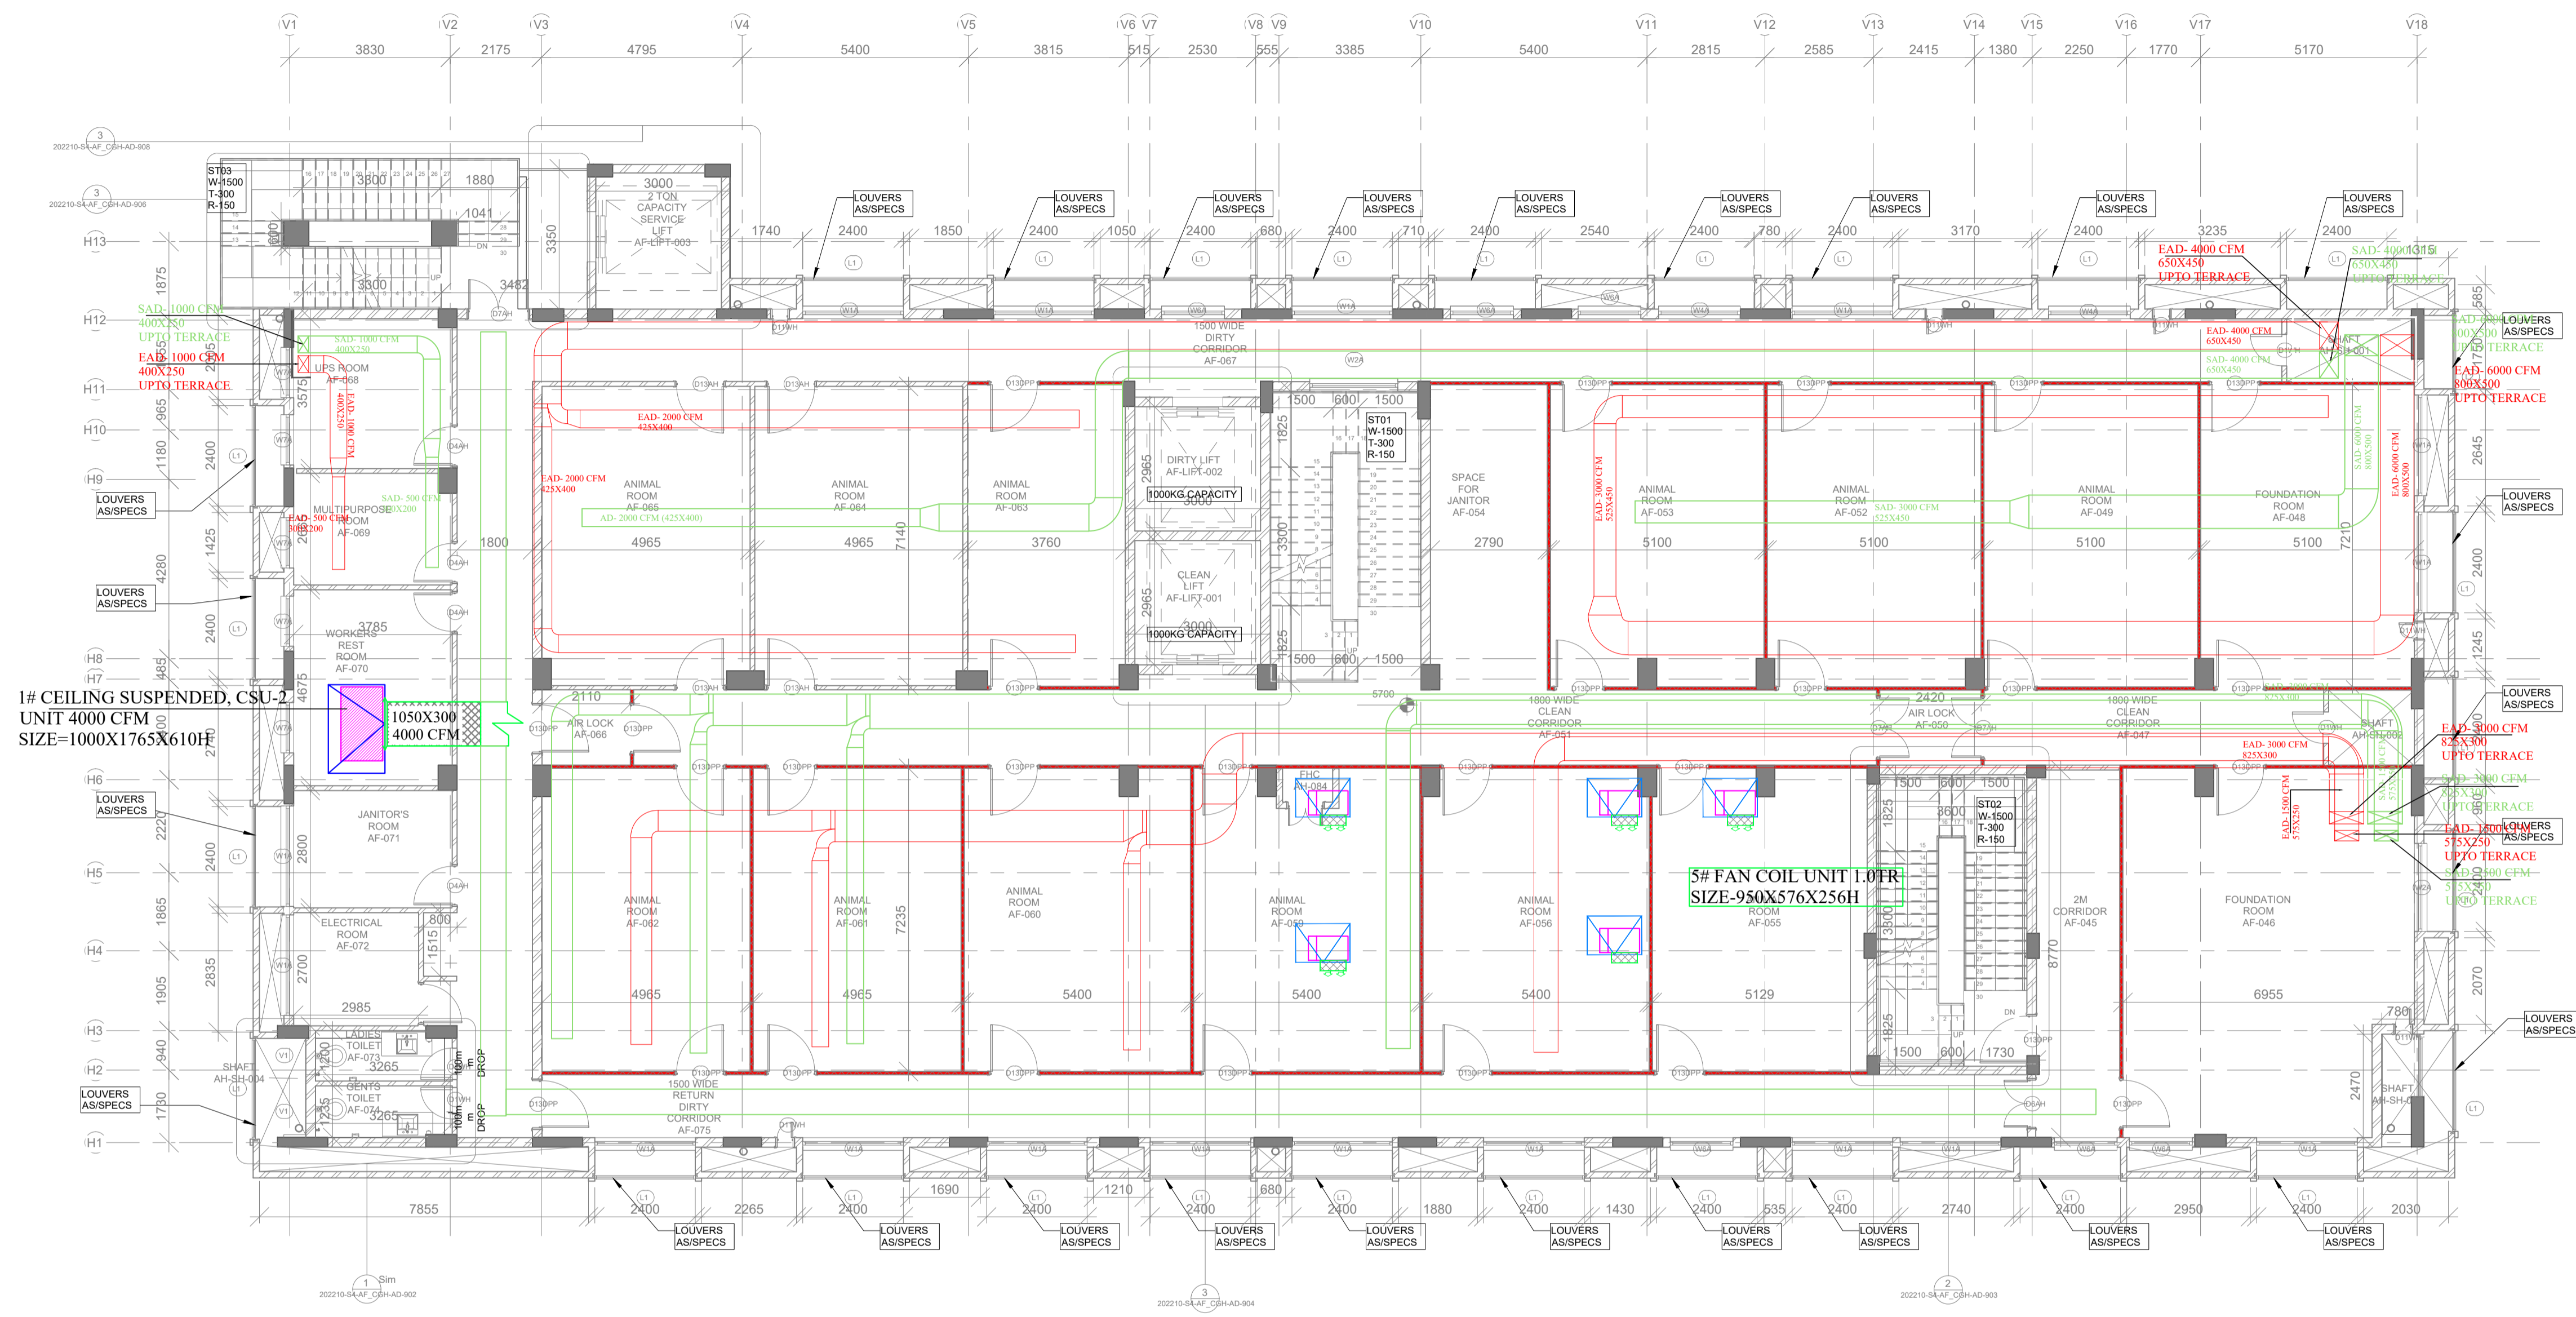


1# CEILING SUSPENDED, CSU-2  
UNIT 4000 CFM  
SIZE=1000X1765X610H

5# FAN COIL UNIT 1.0FR  
SIZE=950X576X256H

HVAC LEGEND	
01	C.S.U UNIT
02	DOUBLE SKIN H.R.W.
03	VENTILATION LINE FAN
04	CHW RETURN PIPE
05	CHW SUPPLY PIPE
06	SUPPLY AIR DUCT
07	EXHAUST AIR DUCT

KEY PLAN:

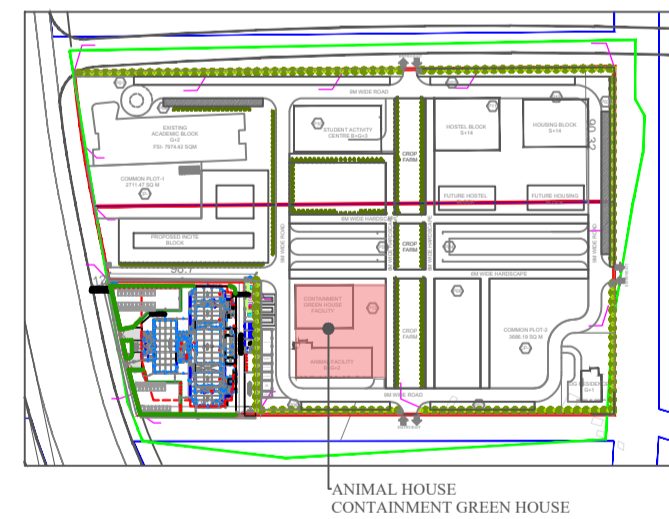

NOTE - ONLY FOR TENDER PURPOSE

DATE	REV	REV BY	DESCRIPTION	DATE	ISSUED TO

**ARCHITECT**  
SURESH GOEL AND ASSOCIATES  
ARCHITECTS . ENGINEERS . PLANNERS

DWG ISSUED ON	BY	AT	PROJECT CODE
16-05-2024	SG	NEW DELHI	202210

ORIGINATED BY	CHECKED BY	VALIDATED BY	BUILDING CODE
S.K	R.SINGH	R.SINGH	AF

**PROJECT:**  
GUJARAT BIOTECHNOLOGY UNIVERSITY

C-85, SHIVALIK  
NEW DELHI-110017  
TEL:(011)26676254,41034450  
MAIL:mail@sgadesignlab.com


FOR TENDER PURPOSE ONLY CLIENT :

**BUILDING TYPE:**  
ANIMAL HOUSE & CONTAINMENT GREEN HOUSE


**DRAWING TITLE:**  
FIRST FLOOR HVAC PLAN AH

**DRAWING NUMBER:**  
202210-AH-S4-HV-004

SCALE: 1:100 SHEET SIZE: A3 SHEET NO: 01

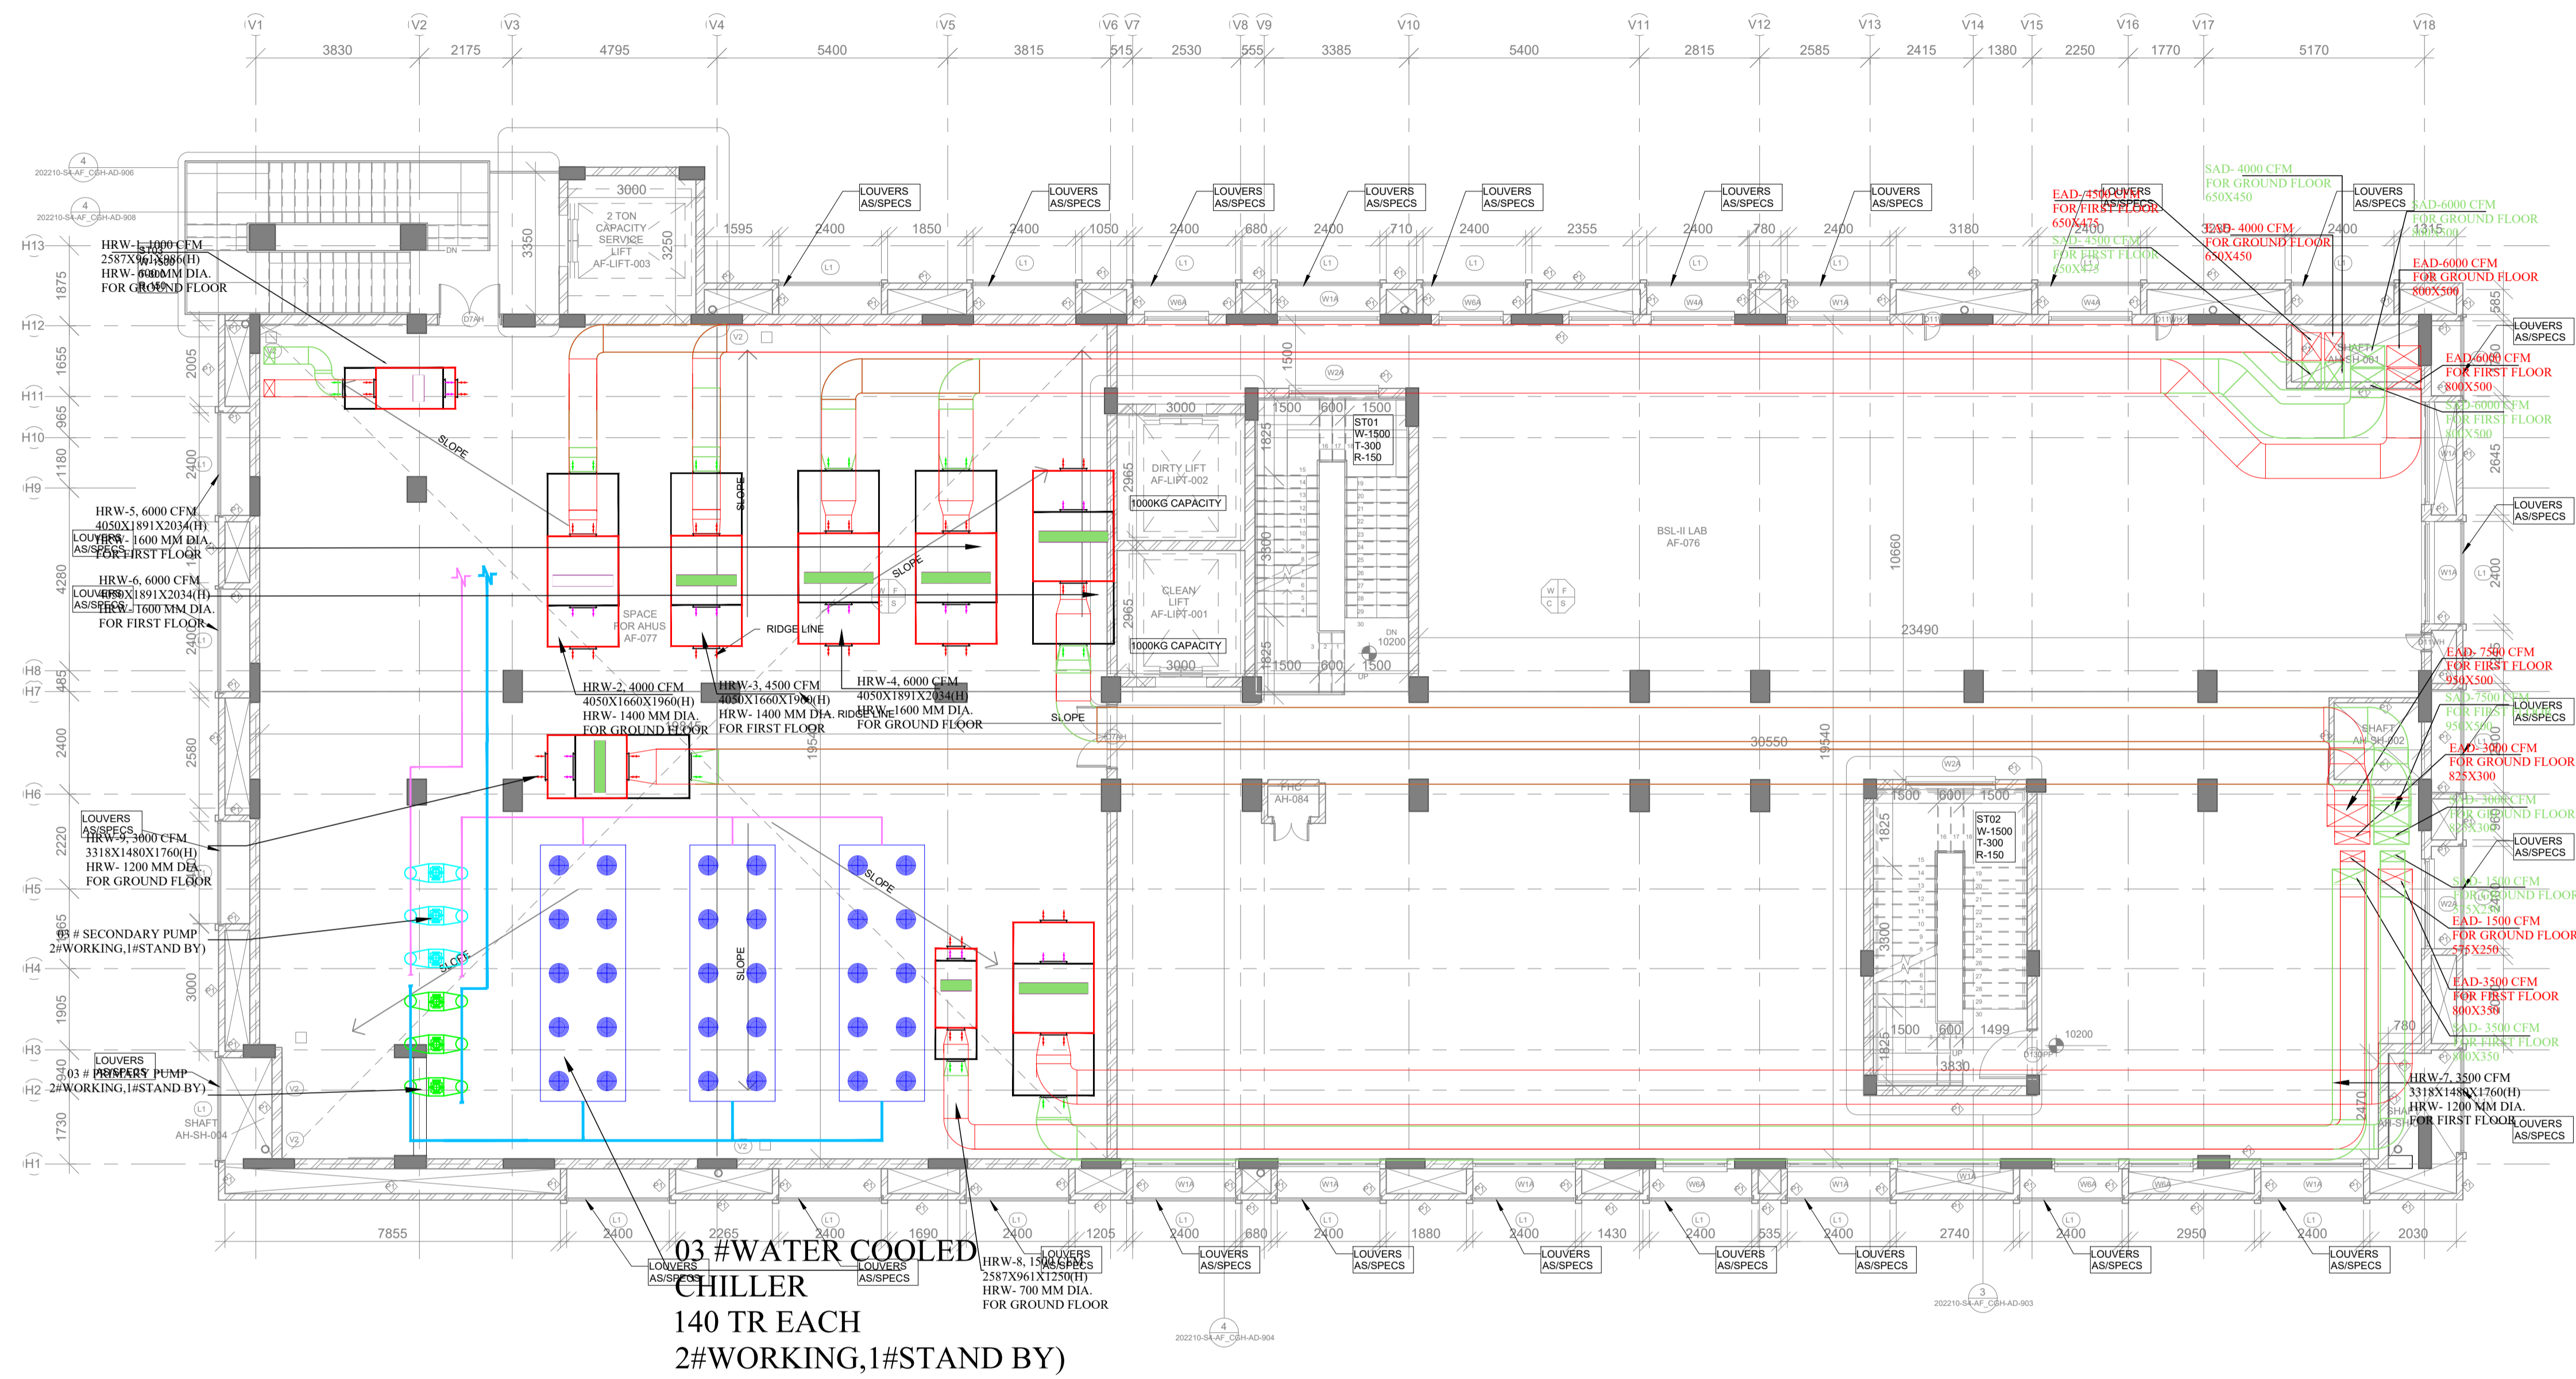

KEY PLAN:

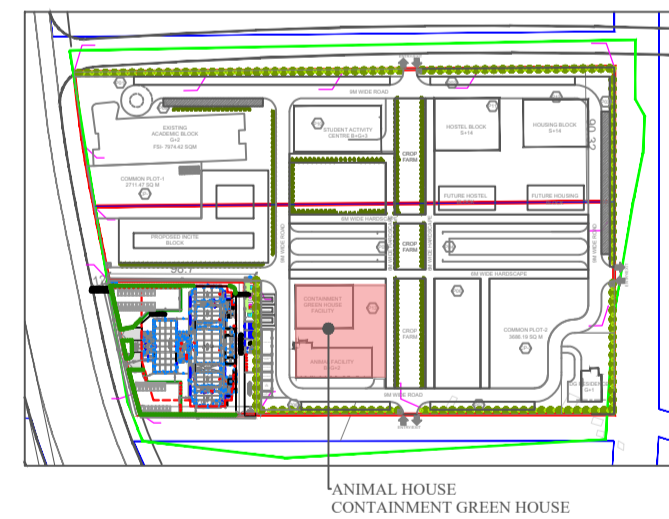

HVAC LEGEND		
01		C.S.U UNIT
02		DOUBLE SKIN H.R.W.
03		VENTILATION LINE FAN
04		CHW RETURN PIPE
05		CHW SUPPLY PIPE
06		SUPPLY AIR DUCT
07		EXHAUST AIR DUCT



NOTE - ONLY FOR TENDER PURPOSE

DATE	REV	REV BY	DESCRIPTION	DATE	NO	ISSUED TO

**ARCHITECT**  
SURESH GOEL AND ASSOCIATES  
ARCHITECTS . ENGINEERS . PLANNERS

DWG ISSUED ON	BY	PROJECT CODE
16-05-2024	SG	202210

ORIGINATED BY	CHECKED BY	VALIDATED BY	BUILDING CODE
S.K	R.SINGH	R.SINGH	AF

**PROJECT:**  
GUJARAT BIOTECHNOLOGY UNIVERSITY

C-85, SHIVALIK  
NEW DELHI-110017  
TEL:(011)26676254,41034450  
MAIL:mail@sgadesignlab.com

FOR TENDER PURPOSE ONLY CLIENT :

BUILDING TYPE:	REVISION
ANIMAL HOUSE & CONTAINMENT GREEN HOUSE	
<b>DRAWING TITLE:</b> SECOND FLOOR HVAC PLAN AH	
<b>DRAWING NUMBER:</b> 202210-AH-S4-HV-005	
SCALE: 1:100	SHEET NO: